

DARIA SEAL

MODIFICATIONS

MODEL: House Plans for Zorrillo
Club Quest

SHEET:

TITLE: FLOOR PLAN


DRAWN BY: MLEWISS

DATE: 5-20-06



SCALE: 1/4" = 1'-0"

A-1

Unless the LORD builds the house,
its builders labor in vain.
Unless the LORD watches over the city,
the watchmen stand guard in vain. Psalm 127:1

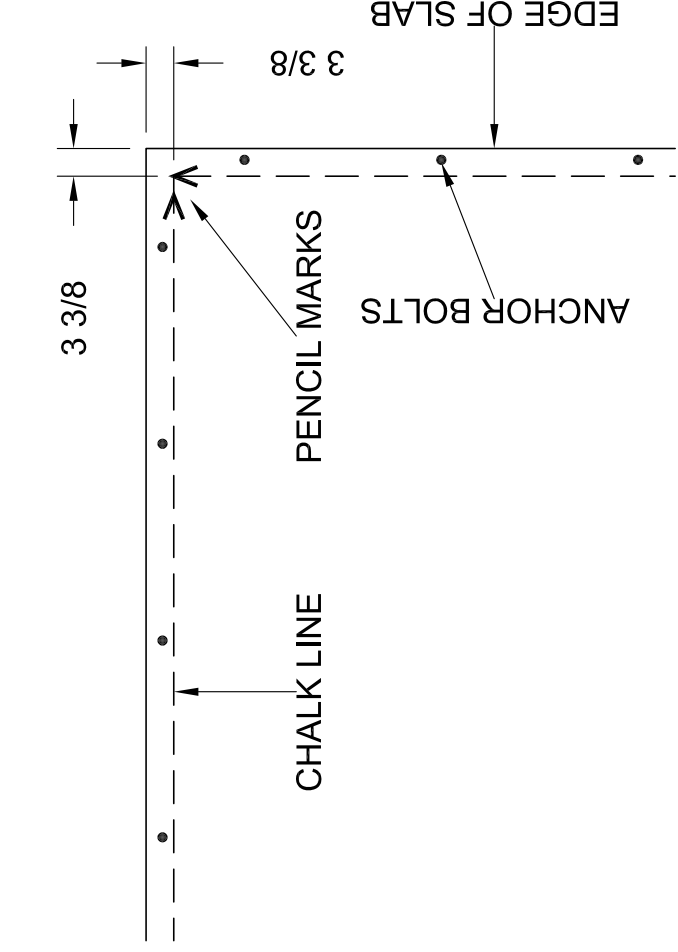


HOLE LOCATION:
 MEASURE **FROM** CHALK LINE
 TO THE CENTER OF THE ANCHOR BOLT
 MARK THE SILL

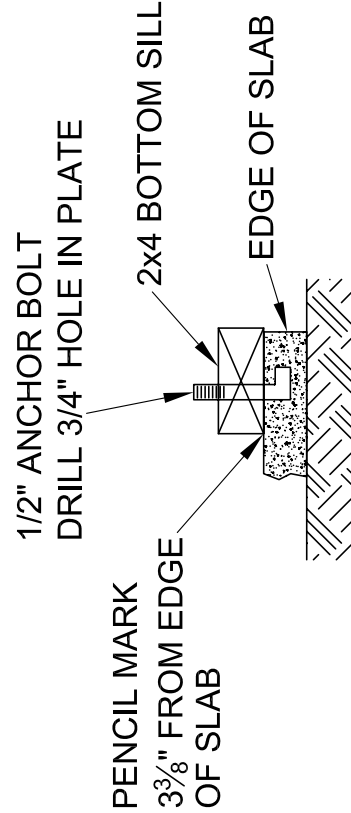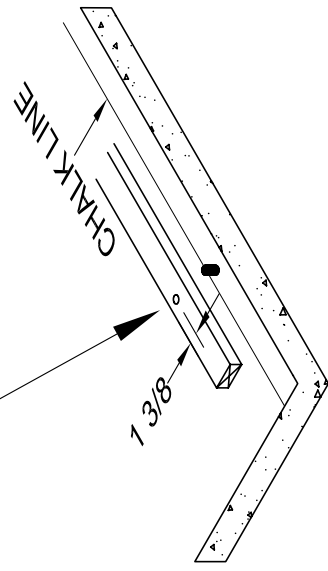


DETAIL 1 - LAYOUT - MARKING - CHALK LINES

DAPIA SEAL	MODIFICATIONS	MODEL: House Plans for Zorrillo Club Quest	SHEET: D-1
	Unless the LORD builds the house, its builders labor in vain. Unless the LORD watches over the city, the watchmen stand guard in vain. Psalm 127:1	TITLE: Detail 1 Layout Lines	DRAWN BY: M.Lewis DATE: 5-20-06
		SCALE: NTS	

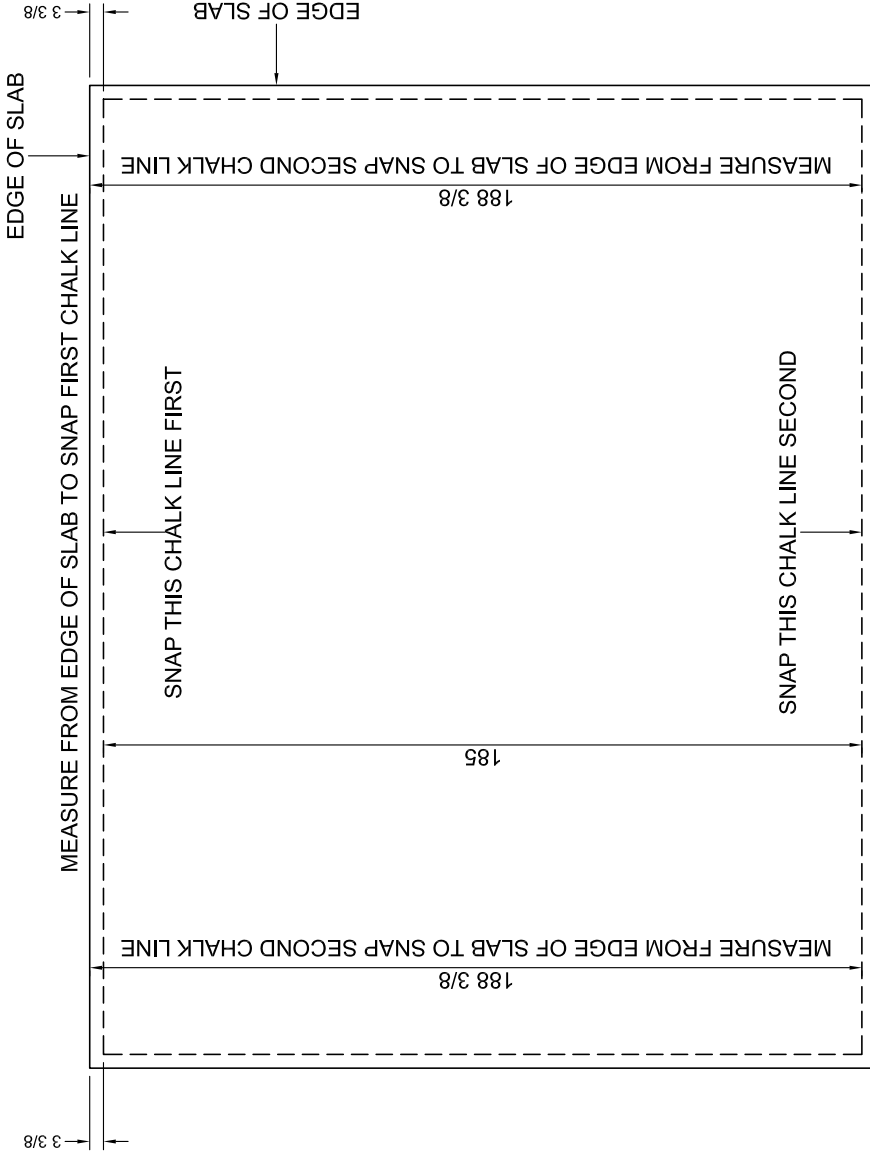


DETAIL 2 - LAYOUT LINES - LONG WALLS FIRST

DAPFA SEAL	MODIFICATIONS	MODEL: House Plans for Zorrillo Club Quest	SHEET: D-2
		TITLE: Detail 2 Layout Lines	
<p>Unless the LORD builds the house, its builders labor in vain. Unless the LORD watches over the city, the watchmen stand guard in vain. Psalm 127:1</p>		DRAWN BY: MLEWISS	DATE: 5-20-06
		SCALE: 1/4" = 1'-0"	

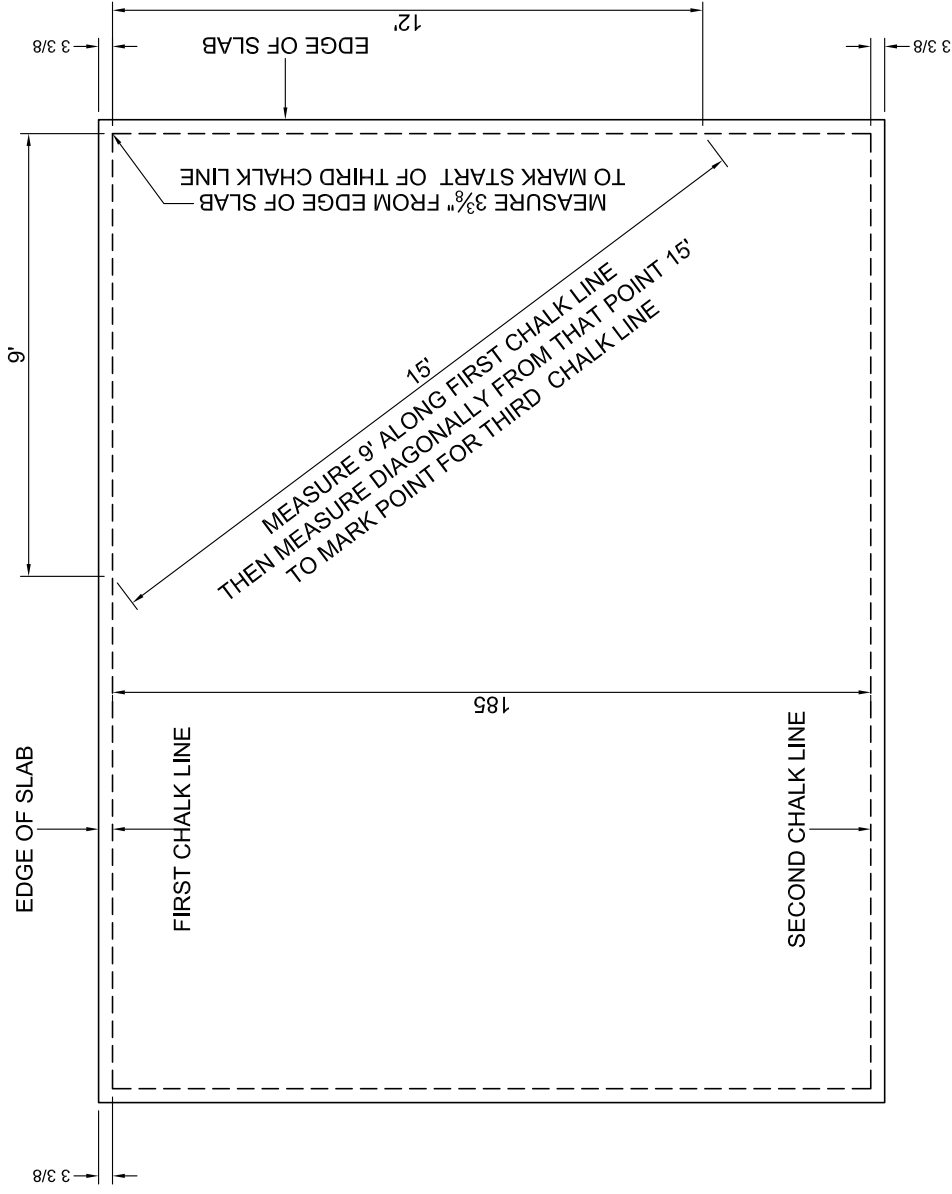





DETAIL 3 - LAYOUT LINES - SHORT WALLS SECOND

DARIA SEAL	MODIFICATIONS 	MODEL: House Plans for Zorrillo Club Quest	SHEET: D-3
	TITLE: Detail 3 Layout Lines		DRAWN BY: MLEWISS DATE: 5-20-06 SCALE: 1/4" = 1'-0"
Unless the LORD builds the house, its builders labor in vain. Unless the LORD watches over the city, the watchmen stand guard in vain. Psalm 127:1			

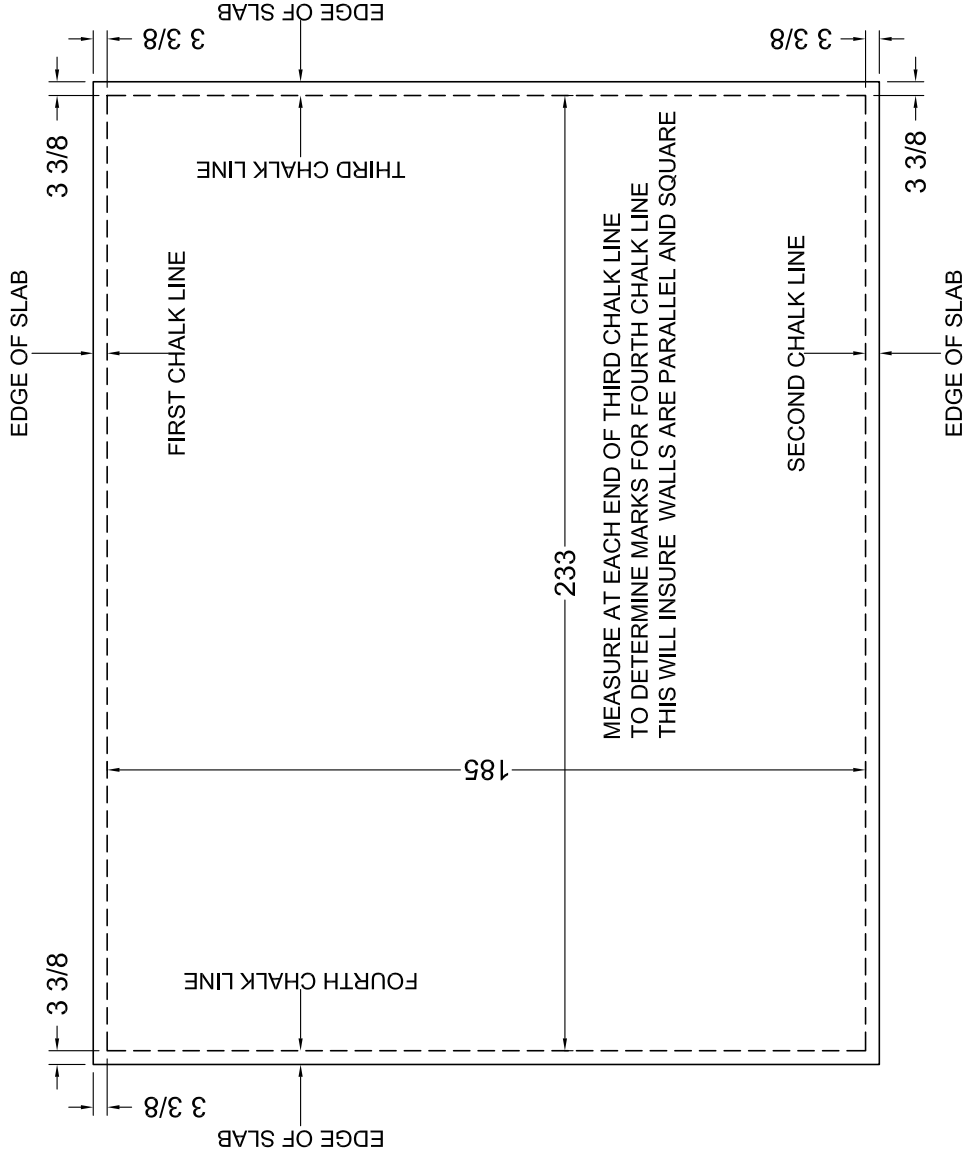

DETAIL 4 - LAYOUT LINES - SHORT WALLS THIRD

DARIA SEAL	MODIFICATIONS	MODEL: House Plans for Zorrillo Club Quest	SHEET: D-4
	<p>Unless the LORD builds the house, its builders labor in vain. Unless the LORD watches over the city, the watchmen stand guard in vain. Psalm 127:1</p>	TITLE: Detail 4 Layout Lines	
		DRAWN BY: MLewisS	DATE: 5-20-06
		SCALE: 1/4" = 1'-0"	

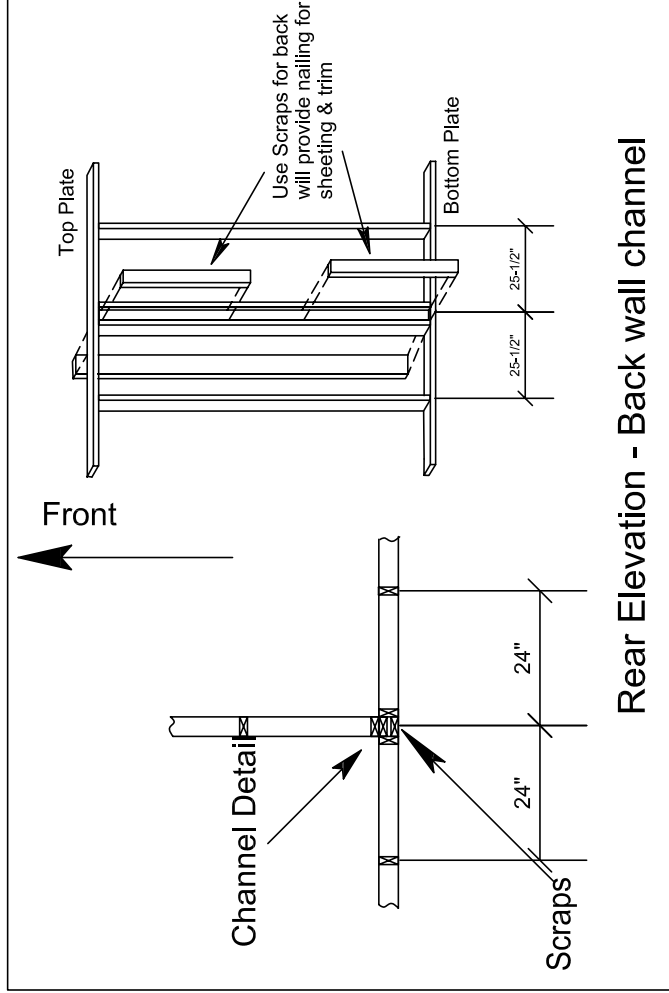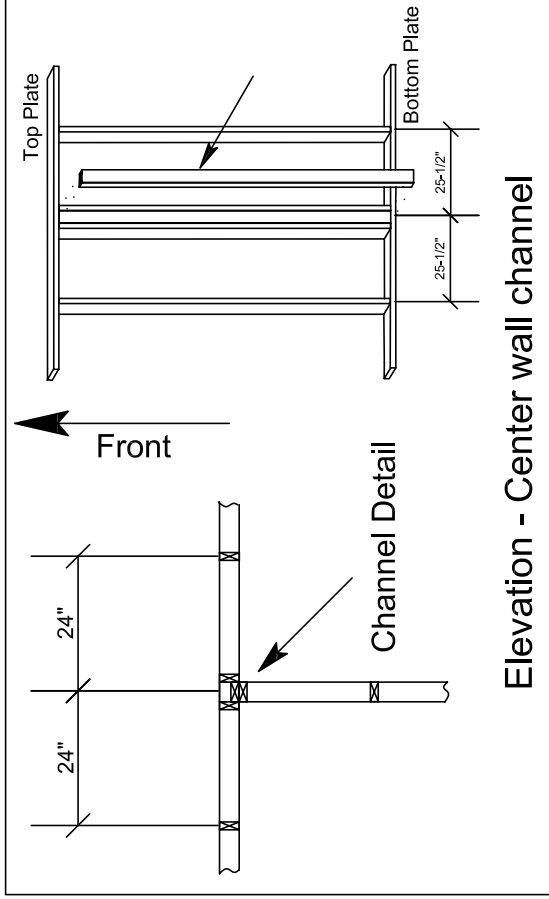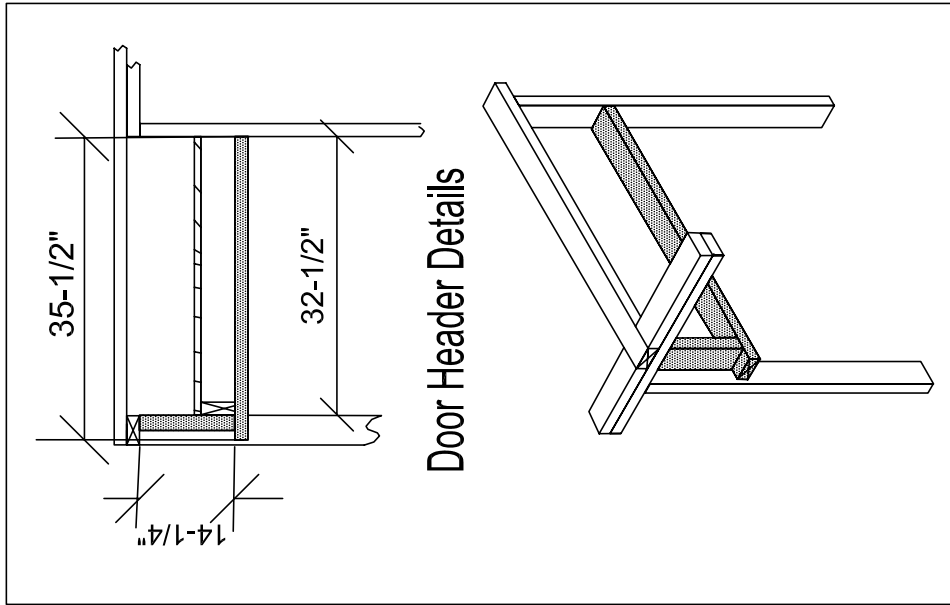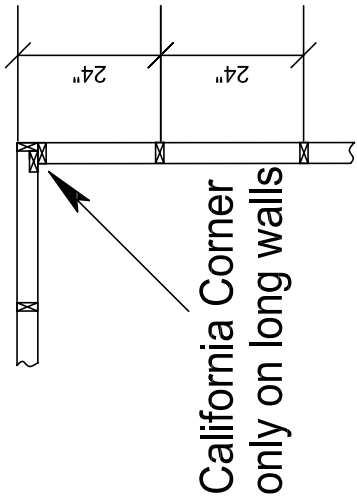

Detail 5 - Floor Plan - Framing Details

DAPIA SEAL MODIFICATIONS Unless the LORD builds the house, its builders labor in vain. Unless the LORD watches over the city, the watchmen stand guard in vain. Psalm 127:1	MODEL: House Plans for Zorrillo Club Quest	SHEET: D-5
	TITLE: Detail 5 Framing Details	DRAWN BY: M Lewis DATE: 5-20-06
	SCALE: NTS	


 
2x6x117" LEDGER

2x6x182" FLOOR/CEILING JOISTS

2x4-117

INSTALL BLOCK EVERY OTHER BAY TO FASTEN JOIST TO FASTEN JOIST

Begin layout with measuring tape "hooked" on the end of the plate. Mark for 24" on center. Make two marks as illustrated. Center stud between points.

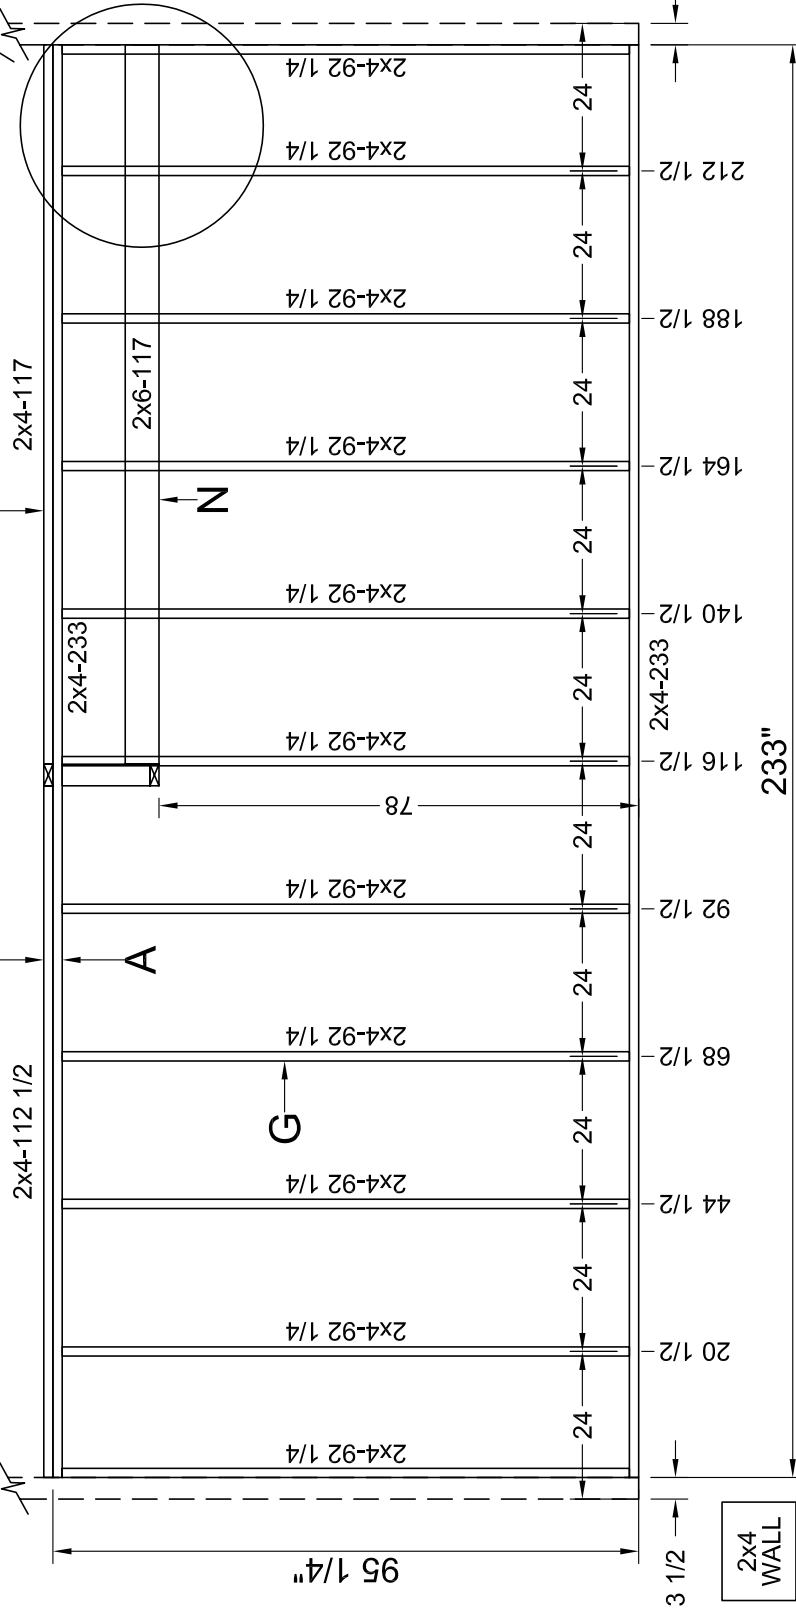

DETAIL 6 - LONG WALL FRAMING LEFT SIDE

VIEWED FROM INSIDE

DAPFA SEAL

MODIFICATIONS

MODEL: House Plans for Zorrillo
Club Quest

SHEET:


TITLE: Detail 6 Framing Details

D-6

DRAWN BY: MLEWIS DATE: 5-20-06

Unless the LORD builds the house, its builders labor in vain. Unless the LORD watches over the city, the watchmen stand guard in vain. Psalm 127:1


SCALE: 3/8" = 1'-0"

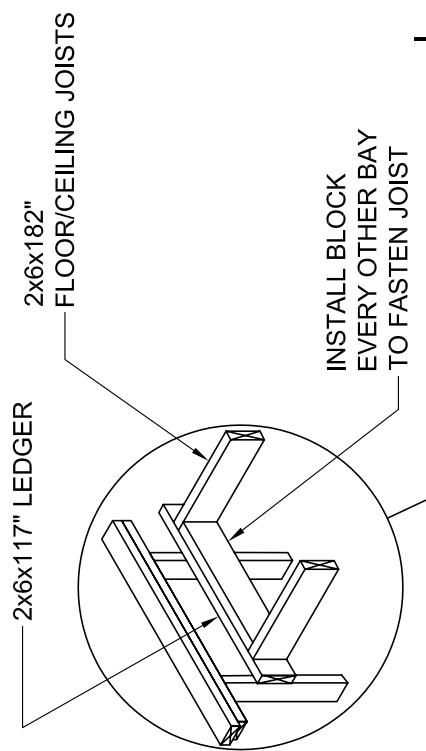


2x6x117" LEDGER

2x6x182" FLOOR/CEILING JOISTS

INSTALL BLOCK EVERY OTHER BAY TO FASTEN JOIST

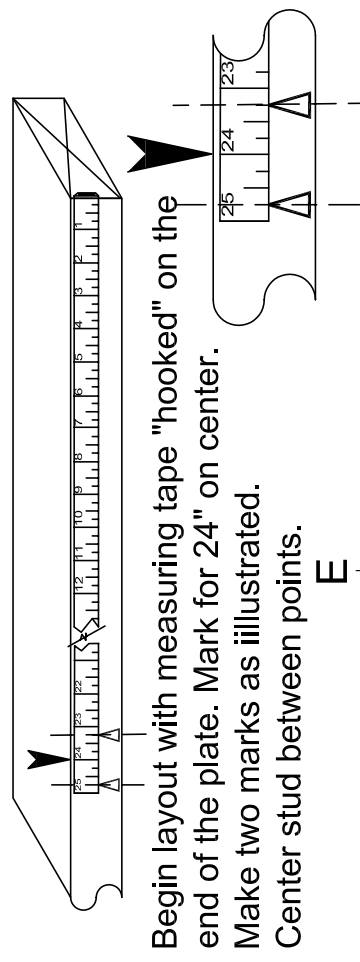

Begin layout with measuring tape "hooked" on the end of the plate. Mark for 24" on center. Make two marks as illustrated. Center stud between points.

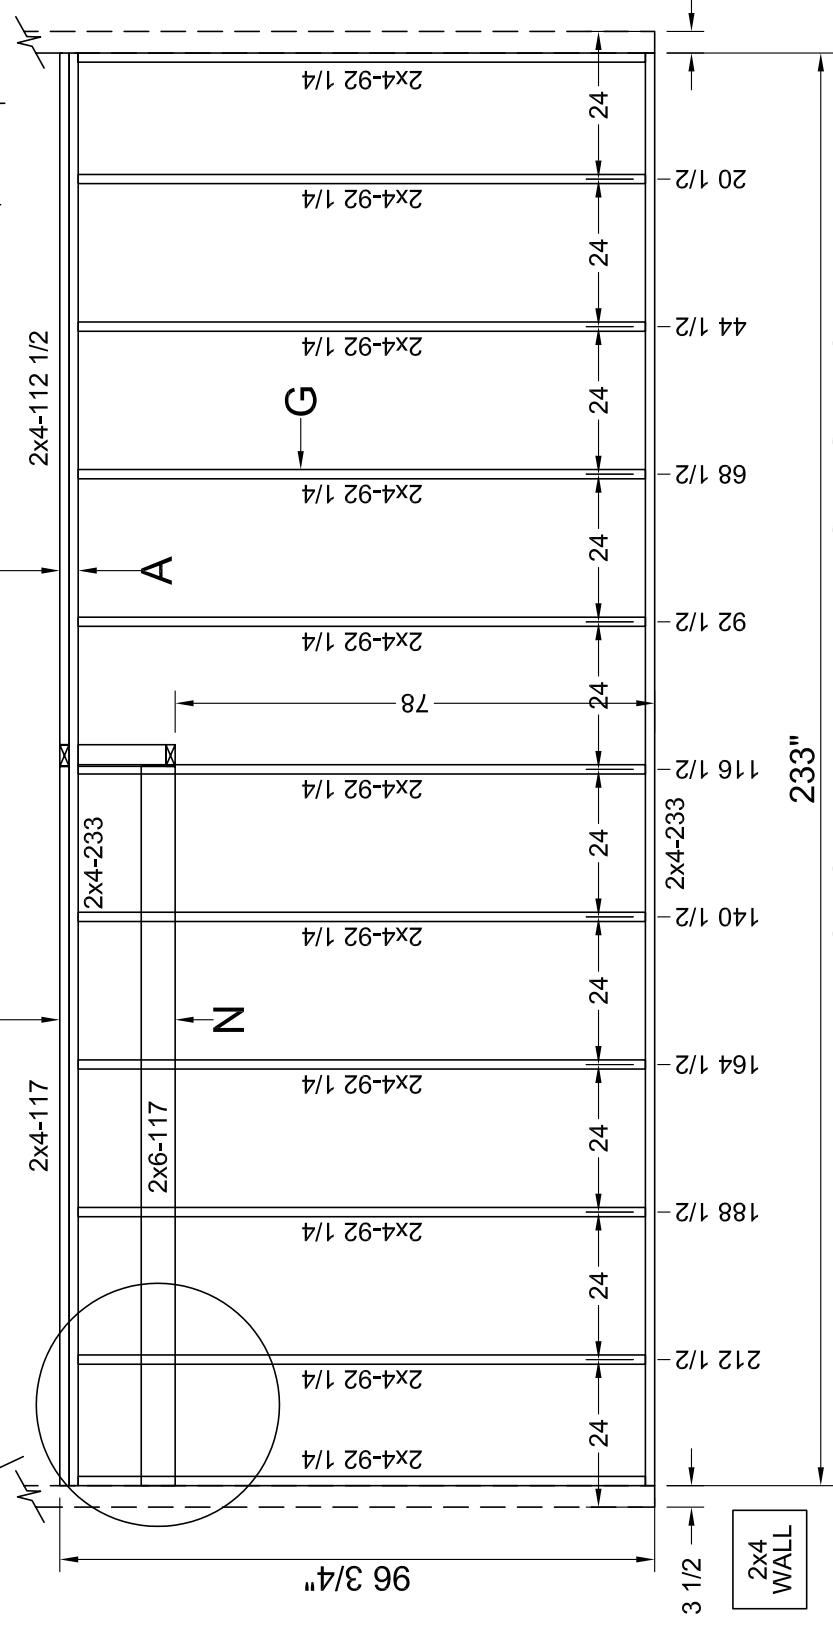


DETAIL 7 - LONG WALL FRAMING RIGHT SIDE

VIEWED FROM INSIDE



DAPIA SEAL	MODIFICATIONS	MODEL: House Plans for Zorrillo <small>Club Quest</small>	SHEET: D-7
	TITLE: Detail 7 Framing Details		DRAWN BY: M.Lewis
	DATE: 5-20-06		SCALE: 3/8" = 1'-0"

Unless the LORD builds the house, its builders labor in vain. Unless the LORD watches over the city, the watchmen stand guard in vain. Psalm 127:1

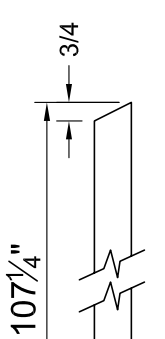

TOP PLATE CUT - 2

ALL ANGLE CUT STUDS/CRIPPLES ARE DIMENSIONED TO THE HIGH SIDE. ANGLE CUT AS SHOWN.

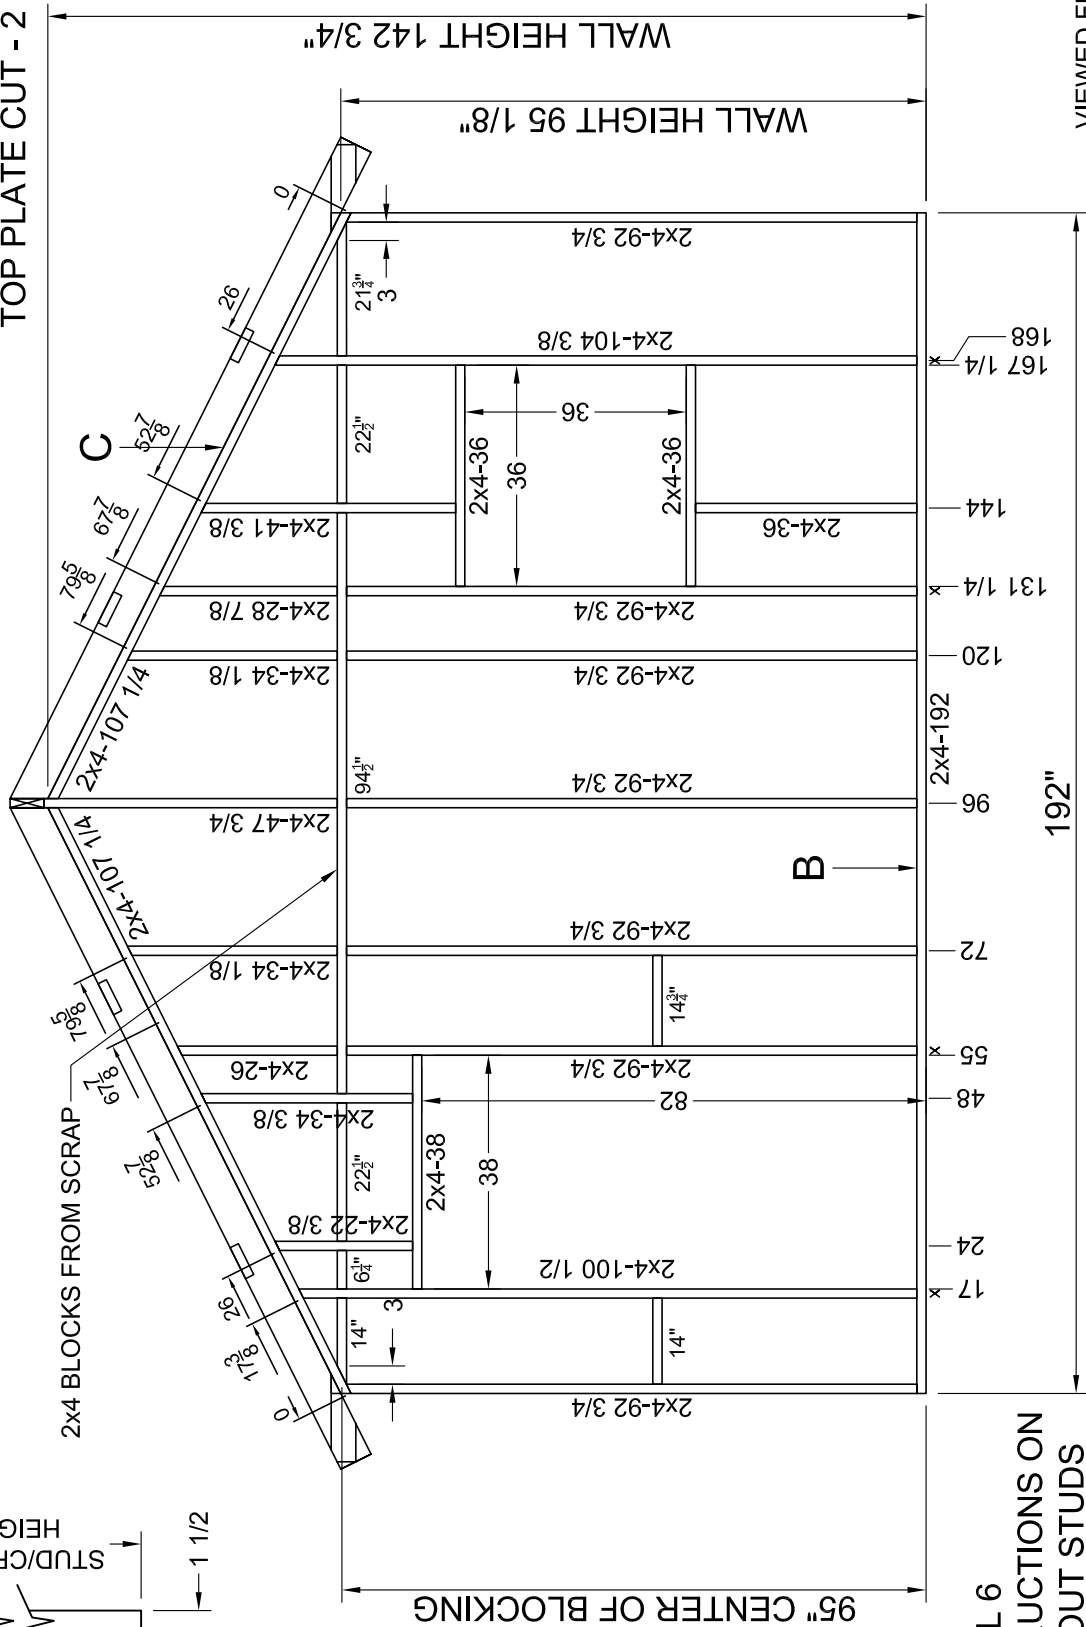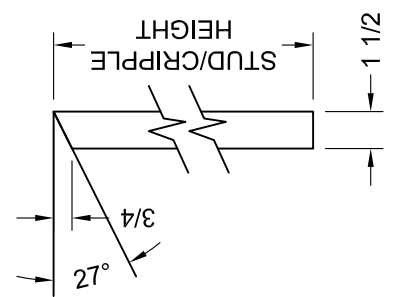


SEE DETAIL 6 FOR INSTRUCTIONS ON MARKING OUT STUDS ON PLATES

VIEWED FROM INSIDE



DETAIL 8 - SHORT WALL FRAMING FRONT

DAPIA SEAL MODIFICATIONS	MODEL: House Plans for Zorrillo Club Quest	SHEET: D-8
	TITLE: Detail 8 Framing Details	DRAWN BY: M.Lewis DATE: 5-20-06
Unless the LORD builds the house, its builders labor in vain. Unless the LORD watches over the city, the watchmen stand guard in vain. Psalm 127:1		
SCALE: 3/8" = 1'-0"		

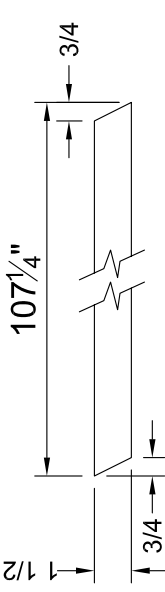

TOP PLATE CUT - 2

ALL ANGLE CUT STUDS/CRIPPLES ARE DIMENSIONED TO THE HIGH SIDE. ANGLE CUT AS SHOWN.

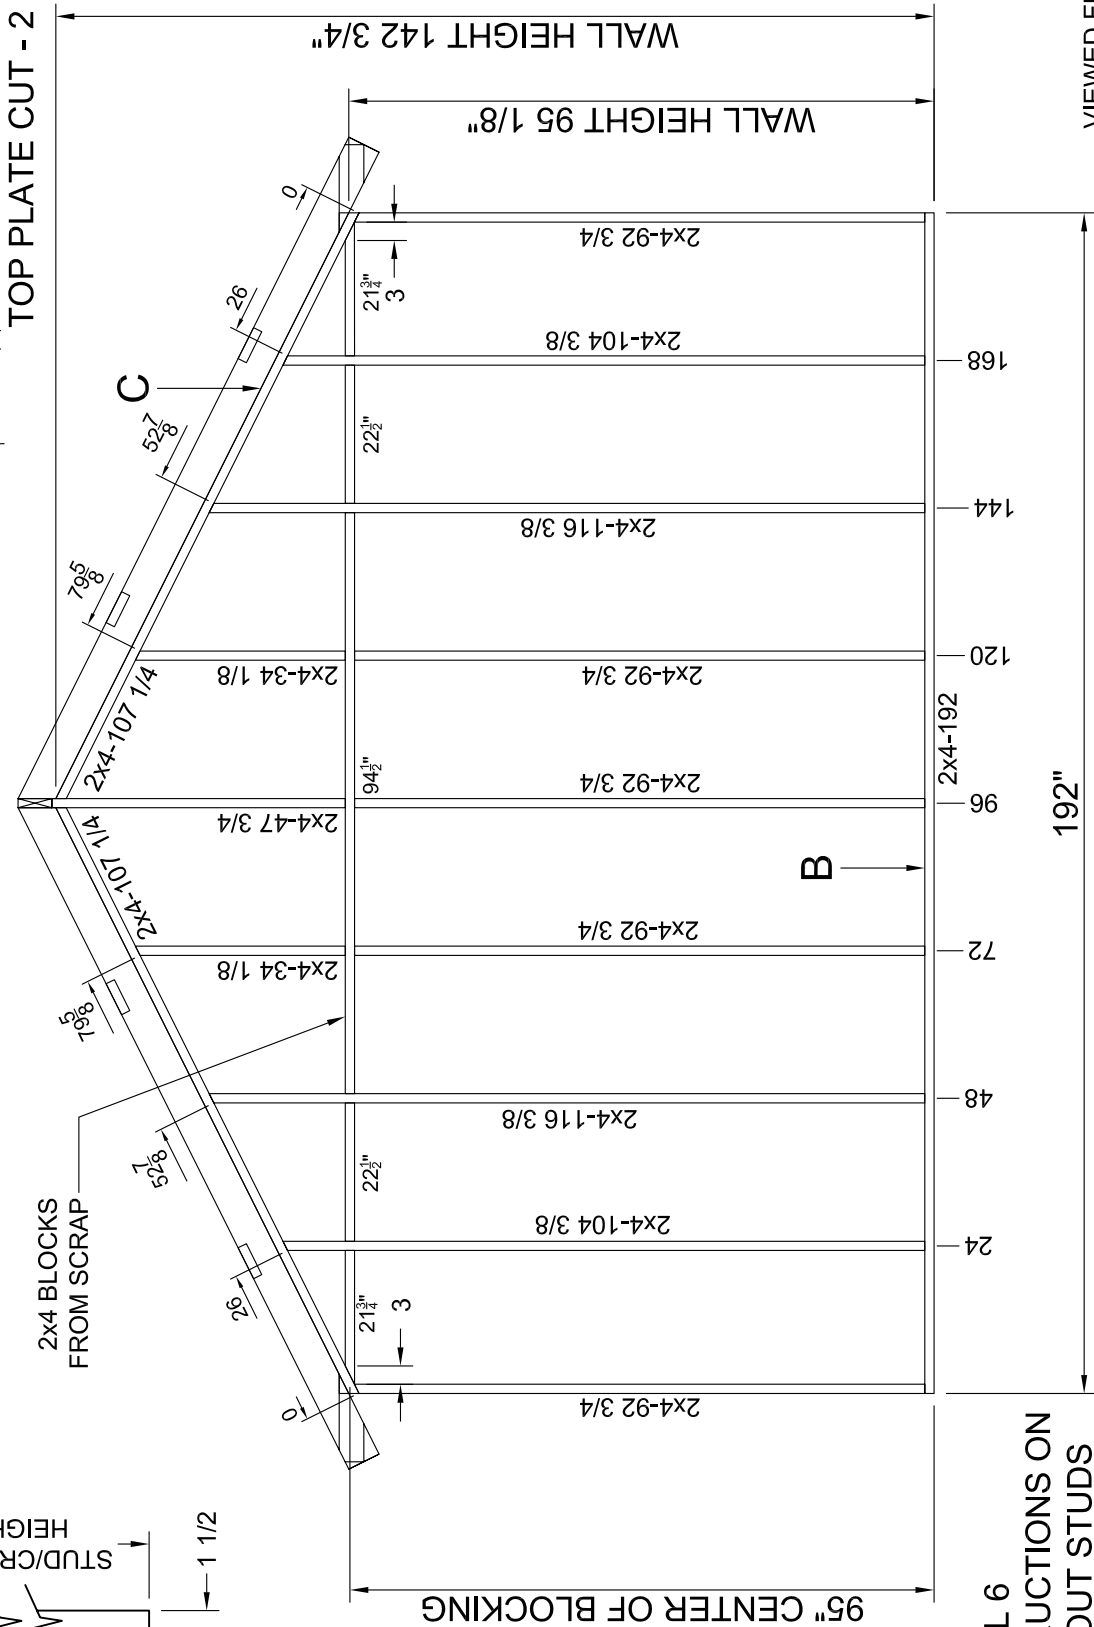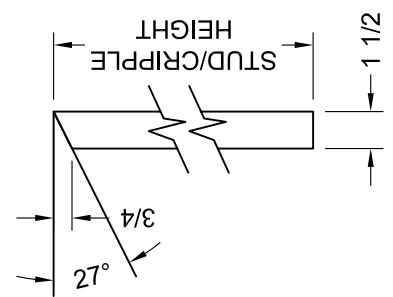


SEE DETAIL 6 FOR INSTRUCTIONS ON MARKING OUT STUDS ON PLATES


VIEWED FROM INSIDE

DETAIL 8-A - SHORT WALL FRAMING FRONT NO OPENINGS

DAPIA SEAL MODIFICATIONS	MODEL: House Plans for Zorrillo Club Quest	SHEET: D-8-A
	TITLE: Detail 8-A Framing Details	DRAWN BY: M.Lewis DATE: 5-20-06
Unless the LORD builds the house, its builders labor in vain. Unless the LORD watches over the city, the watchmen stand guard in vain. Psalm 127:1		
SCALE: 3/8" = 1'-0"		

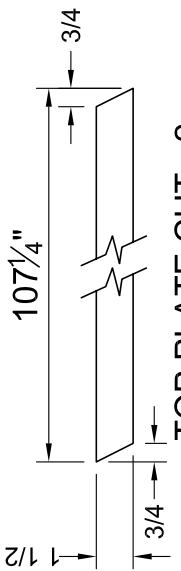


ALL ANGLE CUT STUDS/CRIPPLES ARE DIMENSIONED TO THE HIGH SIDE. ANGLE CUT AS SHOWN.

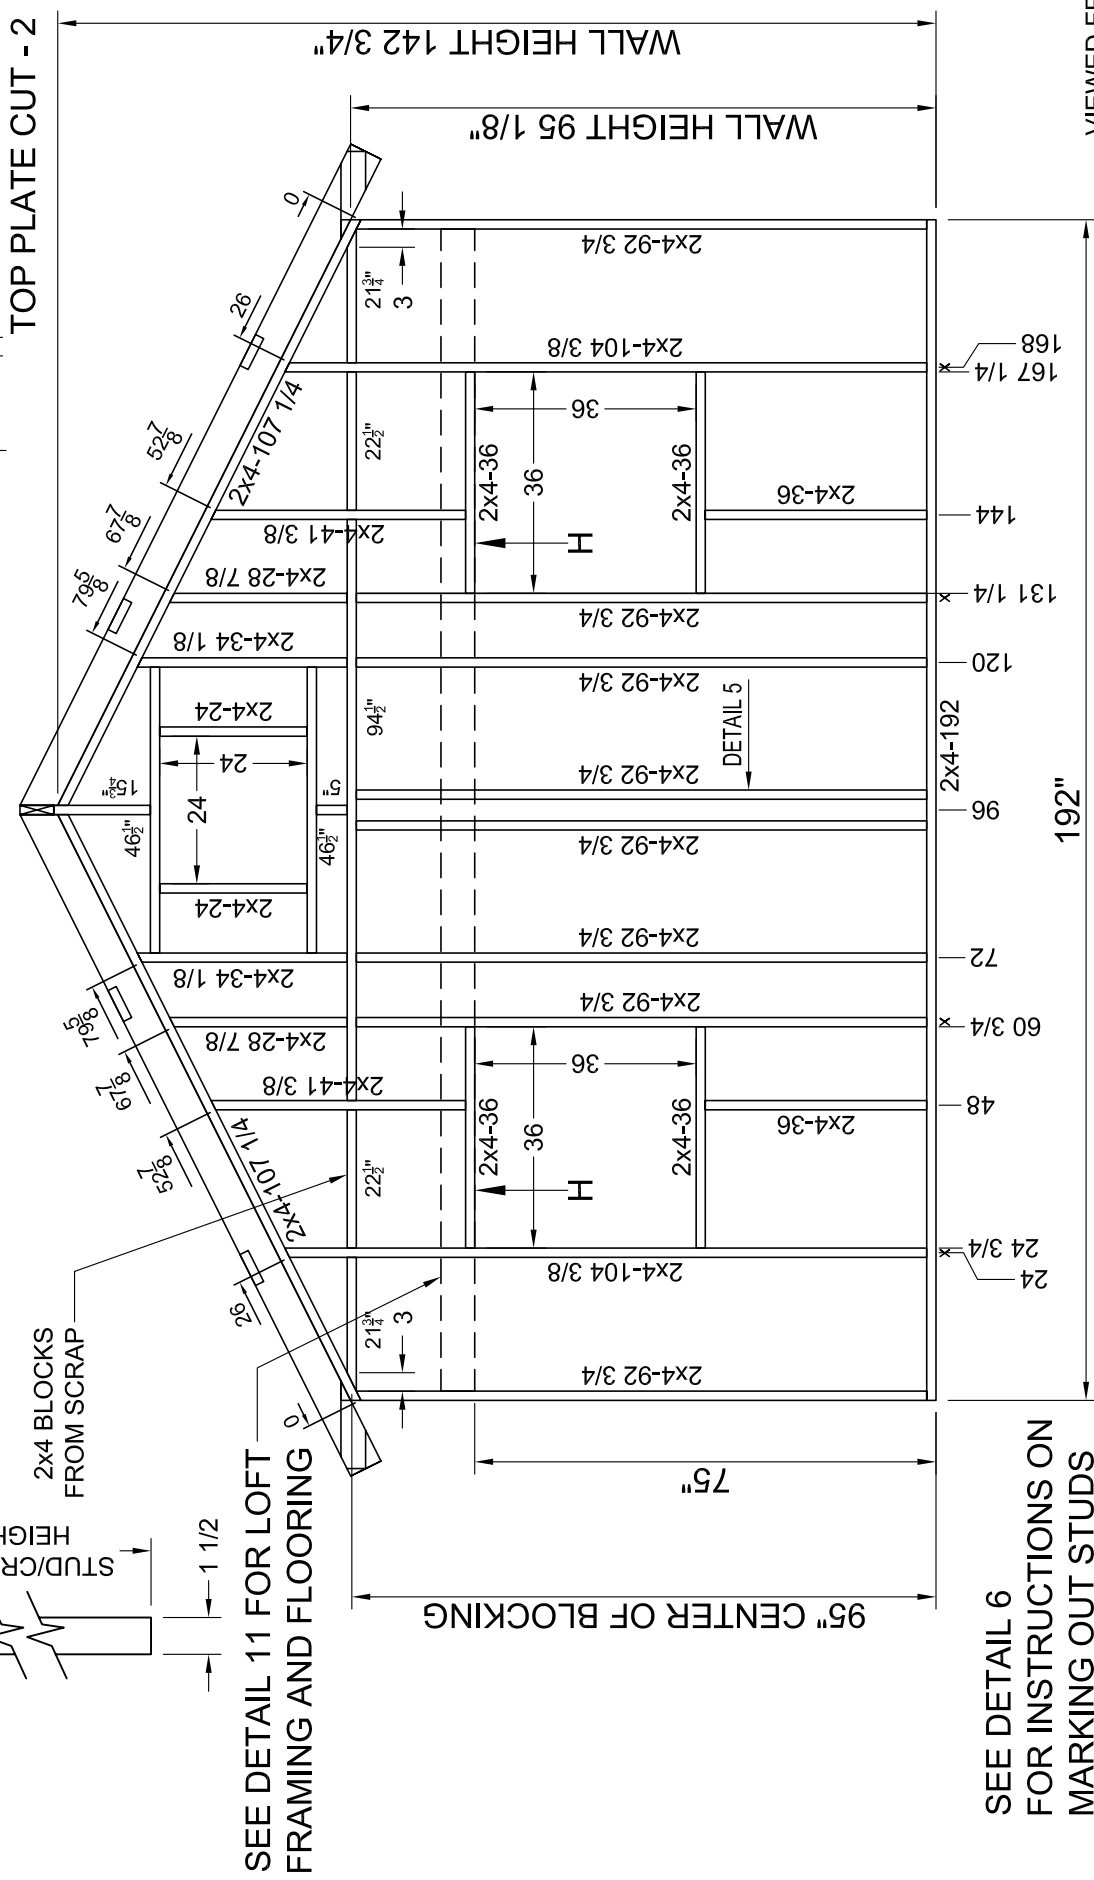


SEE DETAIL 6 FOR INSTRUCTIONS ON MARKING OUT STUDS ON PLATES

DETAIL 9 - SHORT WALL FRAMING REAR

DAPIA SEAL MODIFICATIONS	MODEL: House Plans for Zorrillo Club Quest	SHEET: D-9
	TITLE: Detail 9 Framing Details	DRAWN BY: M.Lewis DATE: 5-20-06
Unless the LORD builds the house, its builders labor in vain. Unless the LORD watches over the city, the watchmen stand guard in vain. Psalm 127:1		
SCALE: 3/8" = 1'-0"		

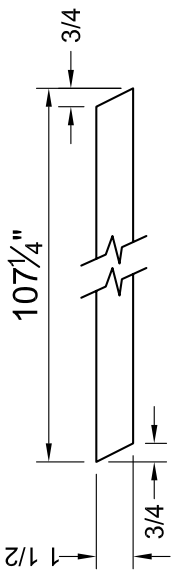



ALL ANGLE CUT STUDS/CRIPPLES ARE DIMENSIONED TO THE HIGH SIDE. ANGLE CUT AS SHOWN.

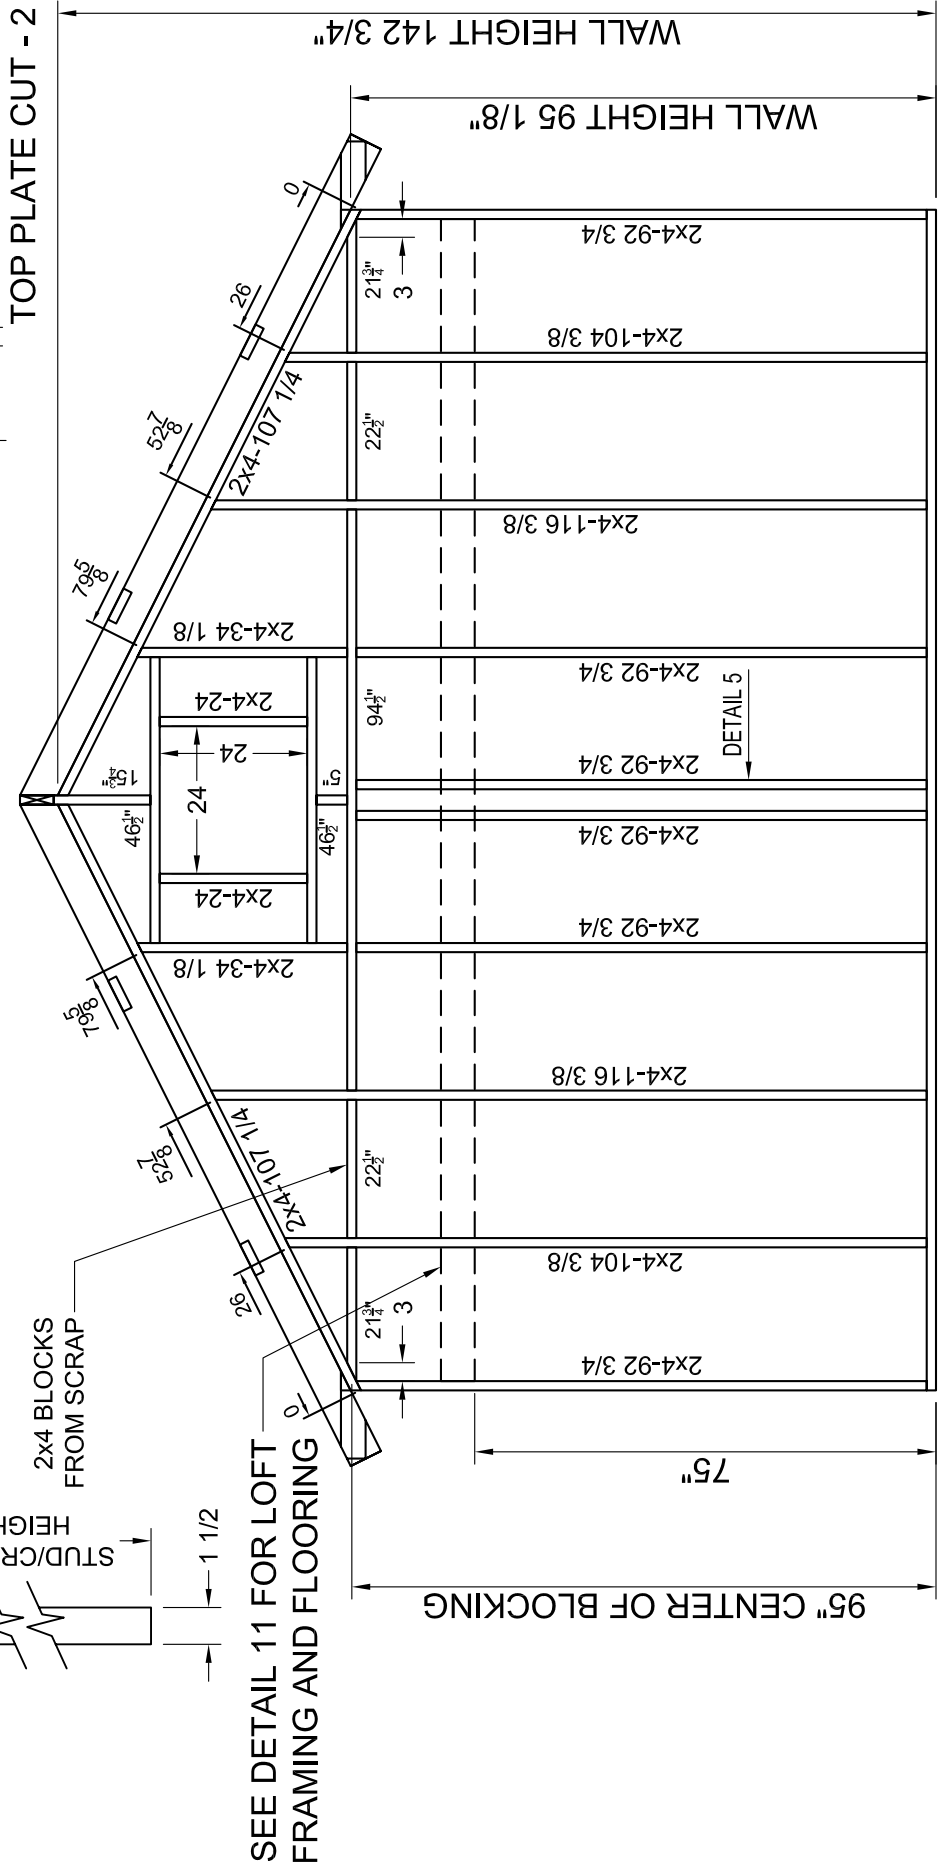

SEE DETAIL 6 FOR INSTRUCTIONS ON MARKING OUT STUDS ON PLATES


DETAIL 9-A - SHORT WALL FRAMING REAR NO LOWER OPENINGS

DAPIA SEAL MODIFICATIONS	MODEL: House Plans for Zorrillo Club Quest	SHEET: D-9-A
	TITLE: Detail 9-A Framing Details	DRAWN BY: M.Lewis DATE: 5-20-06
Unless the LORD builds the house, its builders labor in vain. Unless the LORD watches over the city, the watchmen stand guard in vain. Psalm 127:1		
SCALE: 3/8" = 1'-0"		

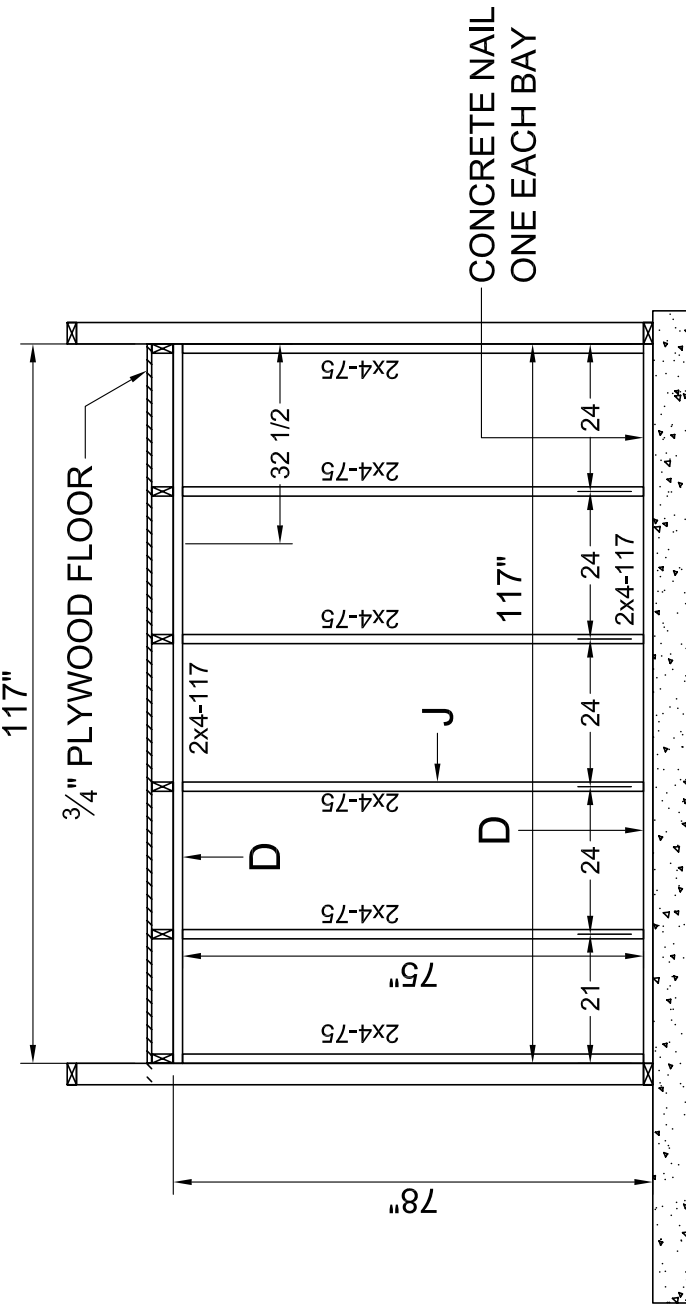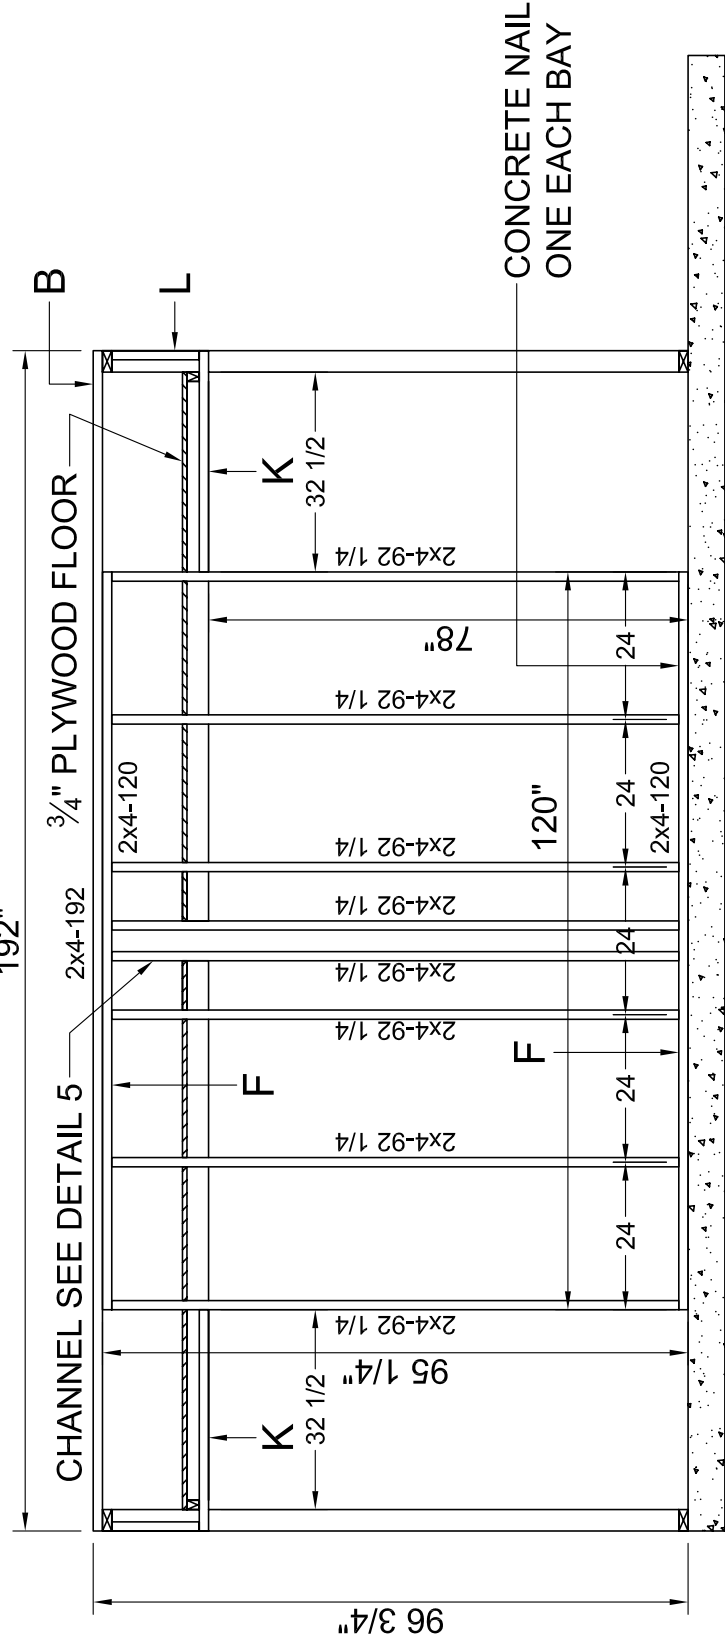

DETAIL 10 - BEDROOM WALL FRAMING


MODEL: House Plans for Zorrillo		DATE: 5-20-06		SCALE: 3/8" = 1'-0"	
TITLE: Detail 10 Framing Details		DRAWN BY: Mlewiss		PROPRIETARY AND CONFIDENTIAL	
SHEET: D-10		Club Quest		PROPRIETARY AND CONFIDENTIAL MATERIALS OF CHAMPION.	
MODIFICATIONS		HOUSE PLANS FOR ZORRILLO		COPYRIGHT © 1976-2006 BY CHAMPION	
DAPIA SEAL					

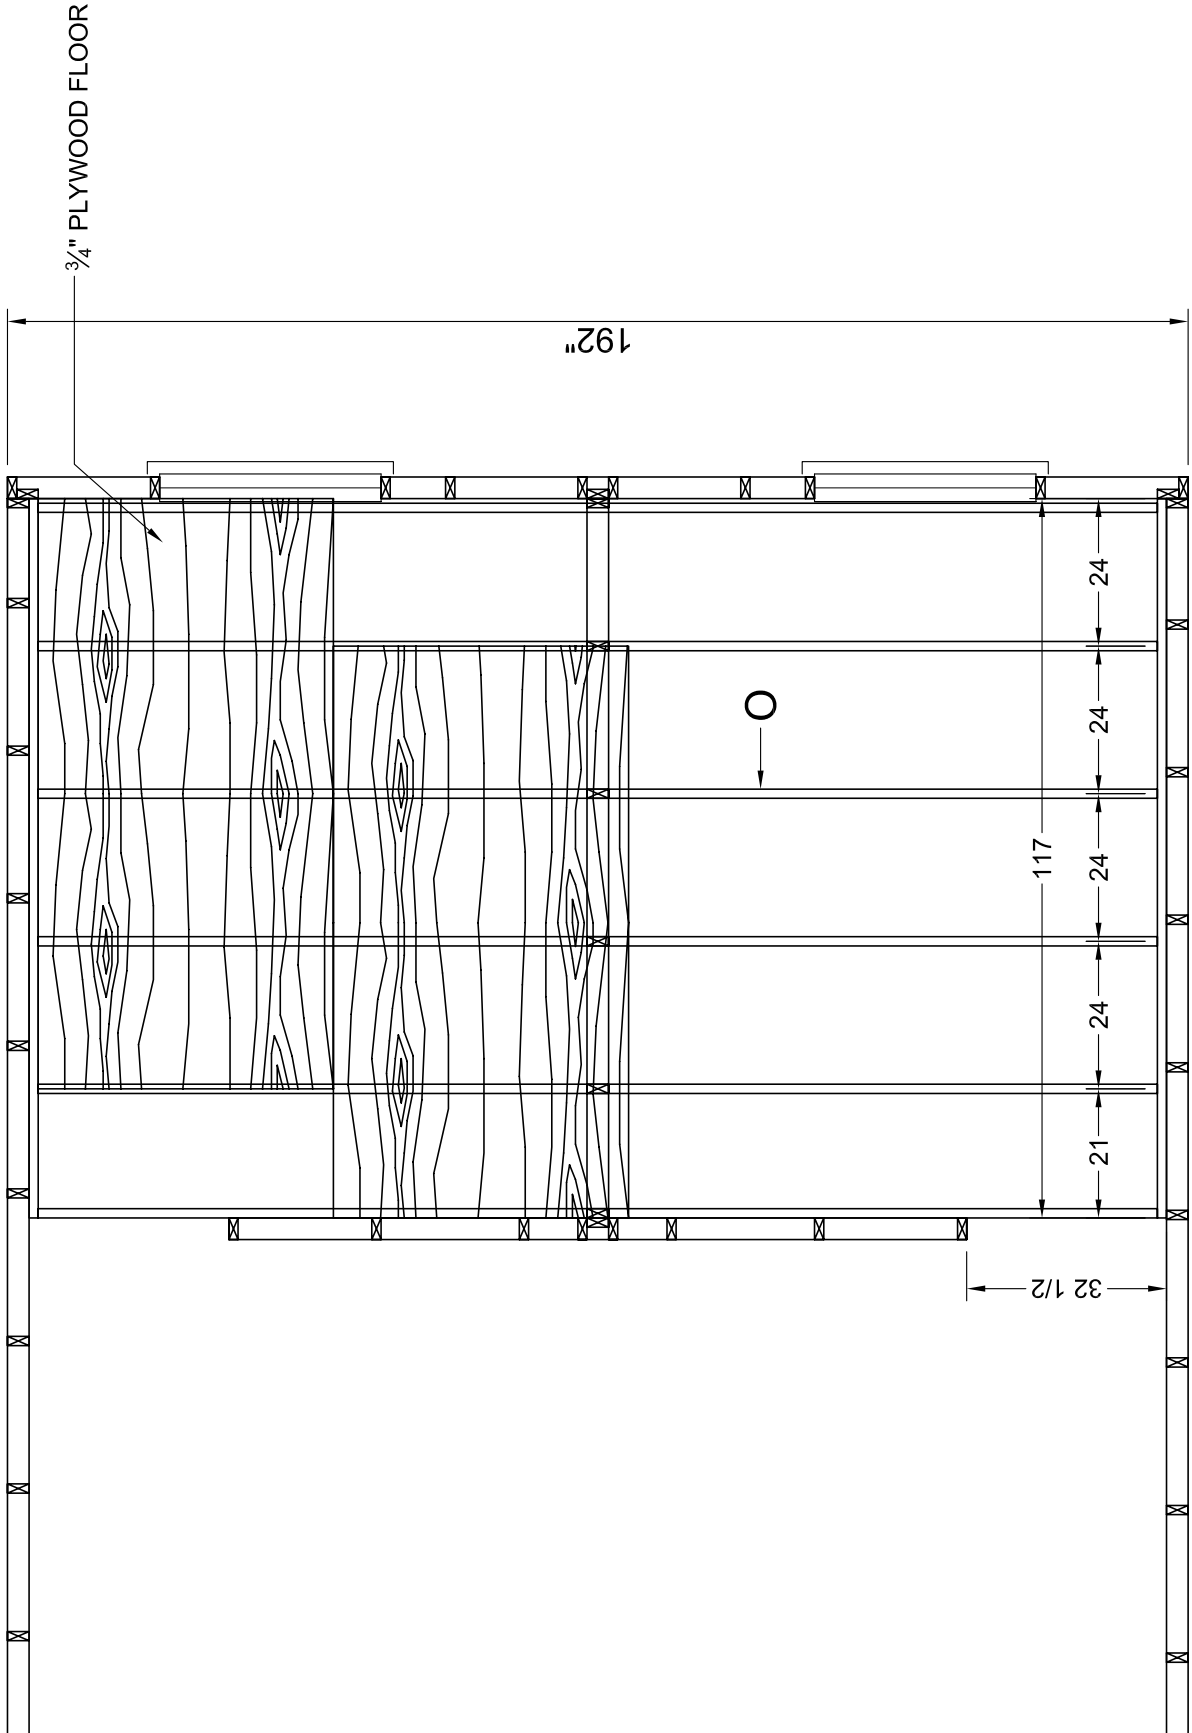

DETAIL 11 - LOFT FRAMING - SHEATHING

DAPIA SEAL MODIFICATIONS	MODEL: House Plans for Zorrillo Club Quest	SHEET: D-11
	TITLE: Detail 11 Loft Framing	
DRAWN BY: MLEWISS DATE: 5-20-06		
SCALE: 3/8" = 1'-0"		
Unless the LORD builds the house, its builders labor in vain. Unless the LORD watches over the city, the watchmen stand guard in vain. Psalm 127:1		


1" PLYWOOD SHEATHING OVERLAP

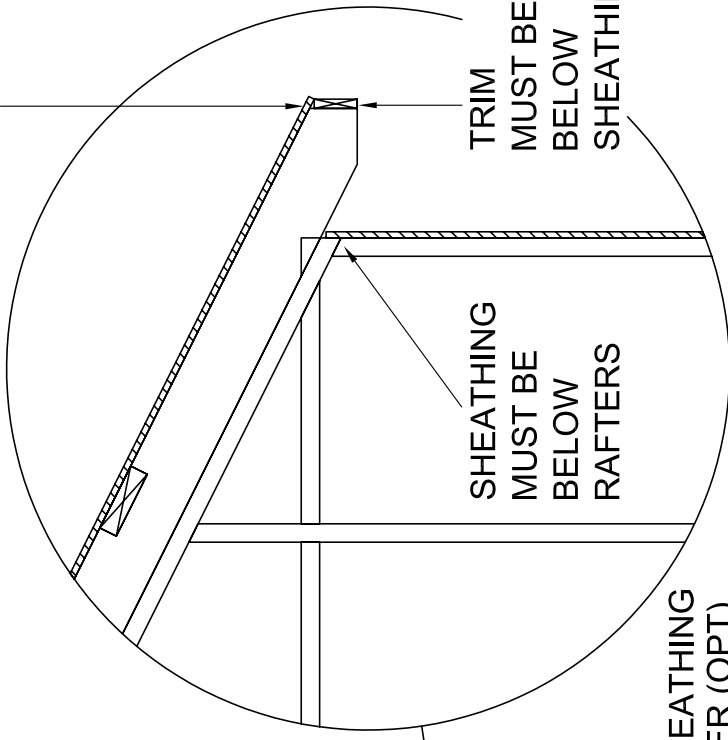

1/2" PLYWOOD SHEATHING

1x4 FASCIA



1/2" PLYWOOD SHEATHING OVER FELT PAPER (OPT) BELOW RAFTERS OVERHANGING SLAB

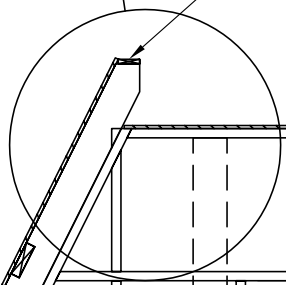

1/2" ANCHOR BOLT


1/2" PLYWOOD SHEATHING OVER FELT PAPER (OPT)

1/2" LAP OVER SLAB

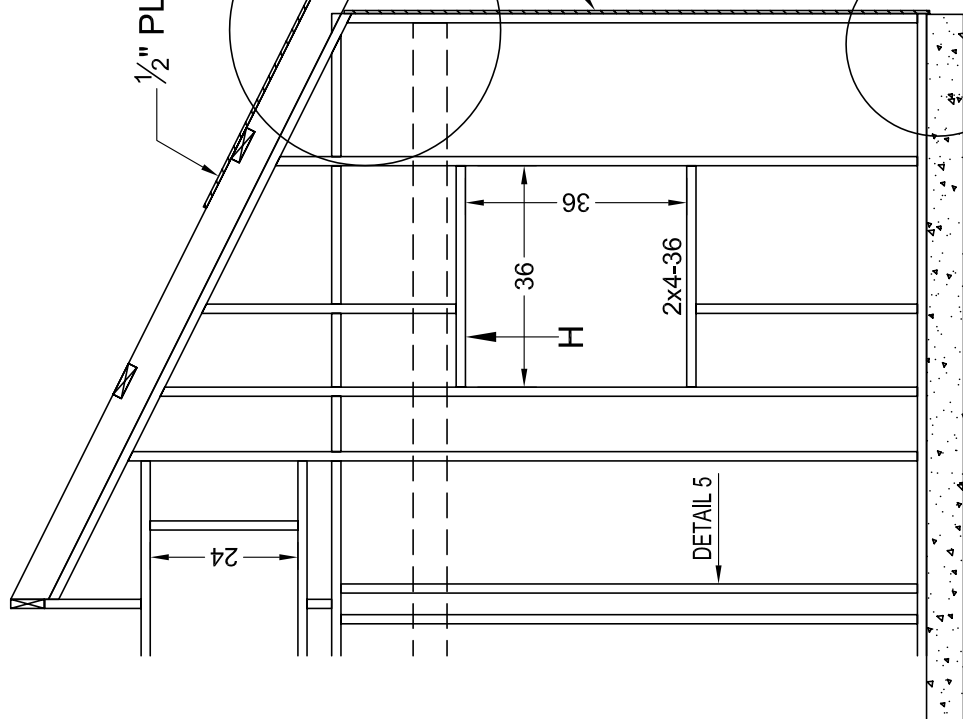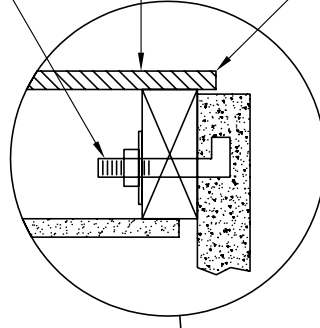

DETAIL 12 - WALL SECTION


DAPIA SEAL MODIFICATIONS	MODEL: House Plans for Zorrillo Club Quest	SHEET: D-12
	TITLE: Detail 12 Wall Section	
Unless the LORD builds the house, its builders labor in vain. Unless the LORD watches over the city, the watchmen stand guard in vain. Psalm 127:1	DRAWN BY: M.Lewis DATE: 5-20-06	
	SCALE: NTS	

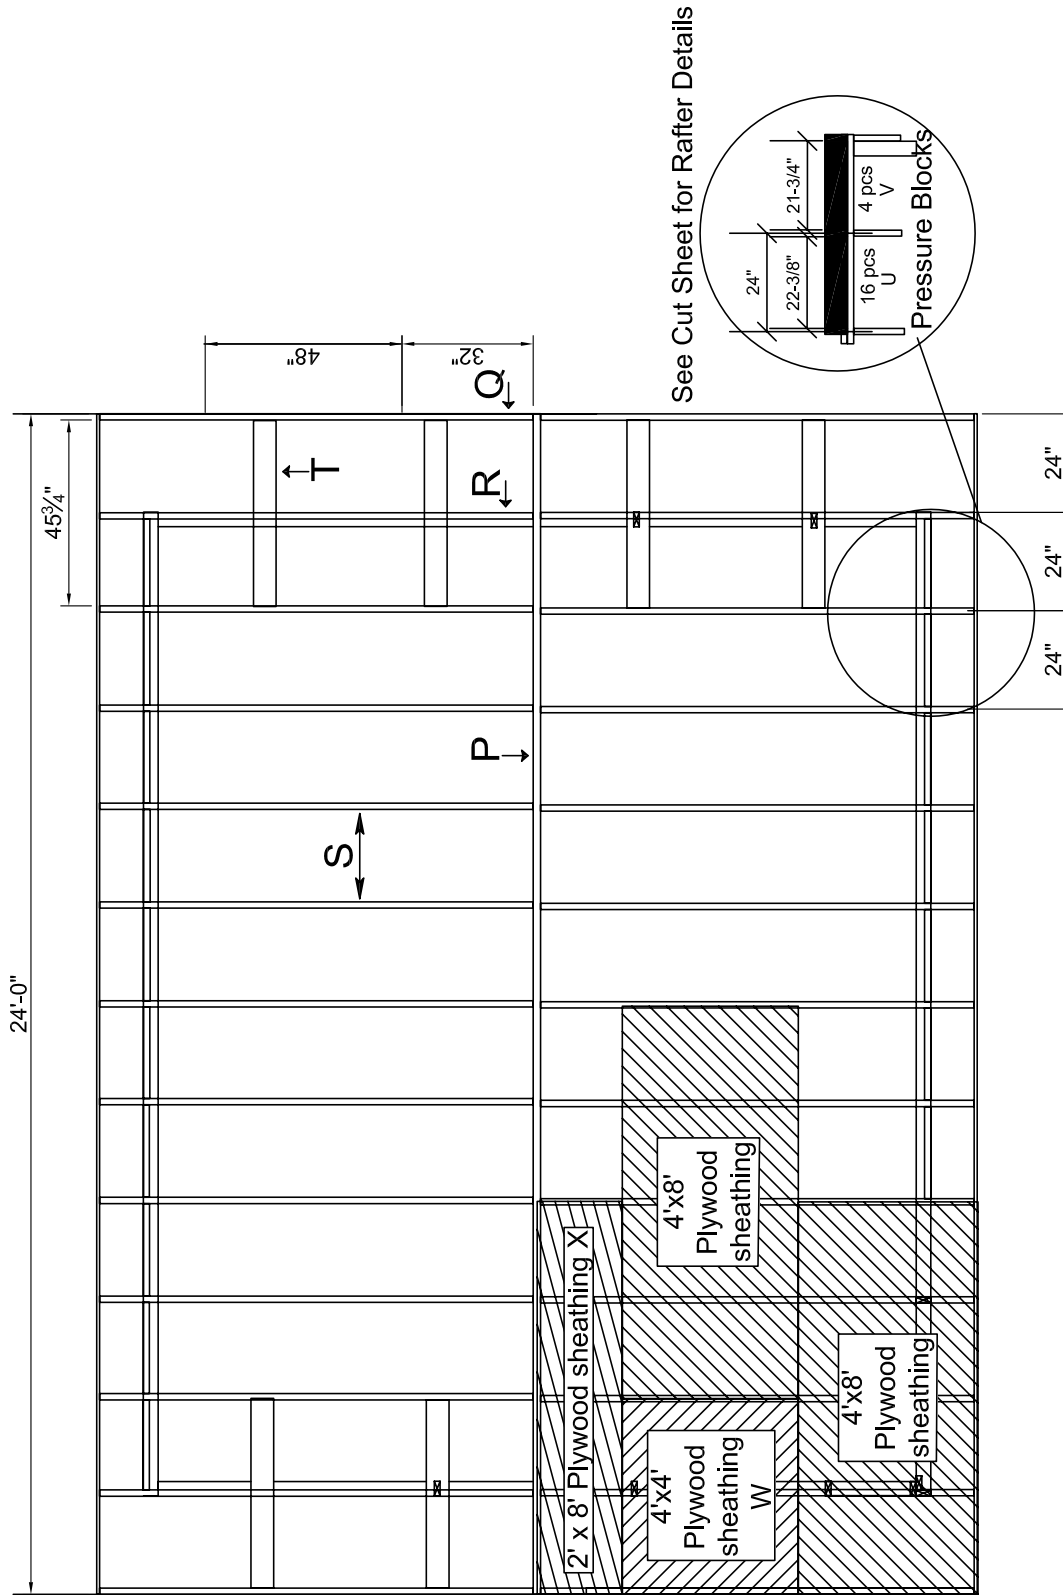

DETAIL 13 - ROOF PLAN - TOP VIEW


DAPIA SEAL	MODIFICATIONS	MODEL: House Plans for Zorrillo Club Quest	SHEET: D-13
		TITLE: Detail 13 Roof Plan	DRAWN BY: M Lewis DATE: 5-20-06
Unless the LORD builds the house, its builders labor in vain. Unless the LORD watches over the city, the watchmen stand guard in vain. Psalm 127:1		SCALE: 1/4" = 1'-0"	DRAWN BY: M Lewis DATE: 5-20-06

1. Framing First
2. Window Second - 1 Nail each corner
3. Plywood Third
4. Trim Last with caulking around the top and sides

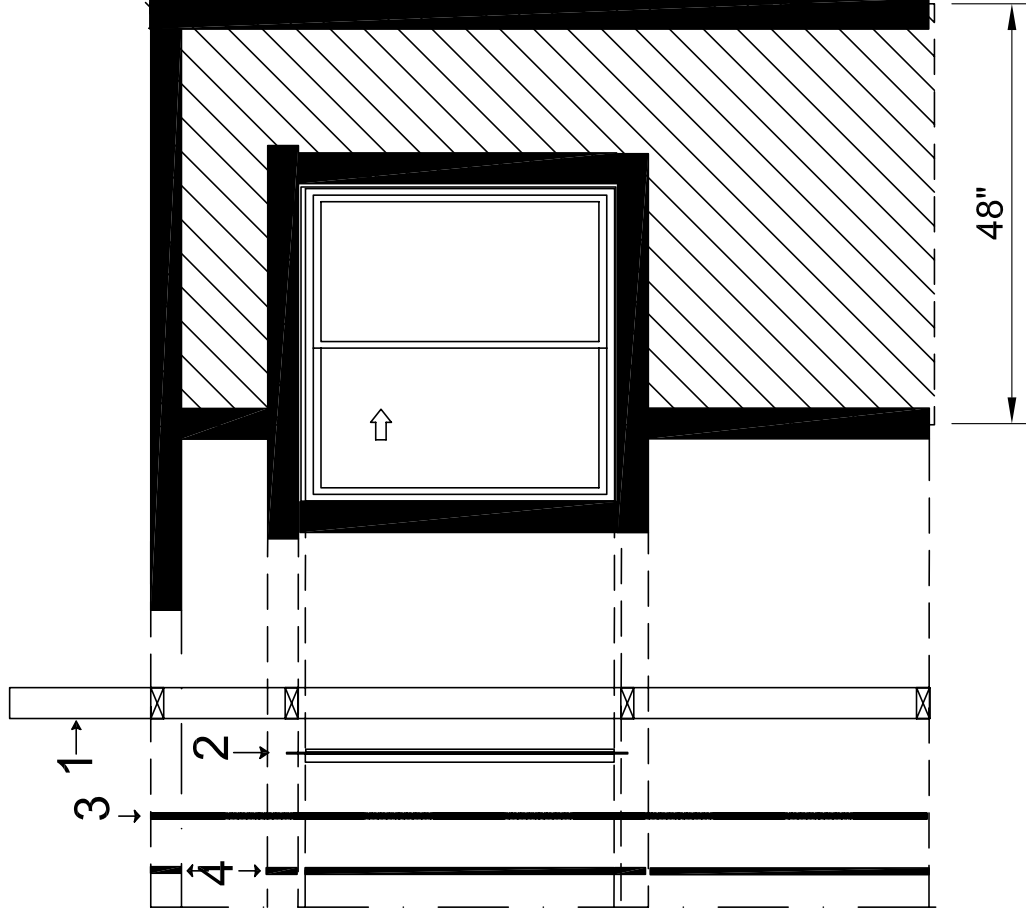

DETAIL 14 - WINDOW INSTALLATION TRIM/SHEATHING


DAPIA SEAL	MODIFICATIONS	MODEL: House Plans for Zorrillo Club Quest	SHEET: D-14
	Unless the LORD builds the house, its builders labor in vain. Unless the LORD watches over the city, the watchmen stand guard in vain. <small>Psalm 127:1</small>	TITLE: Detail 14 Window Trim	DRAWN BY: MLEWISS DATE: 5-20-06
		SCALE: NTS	

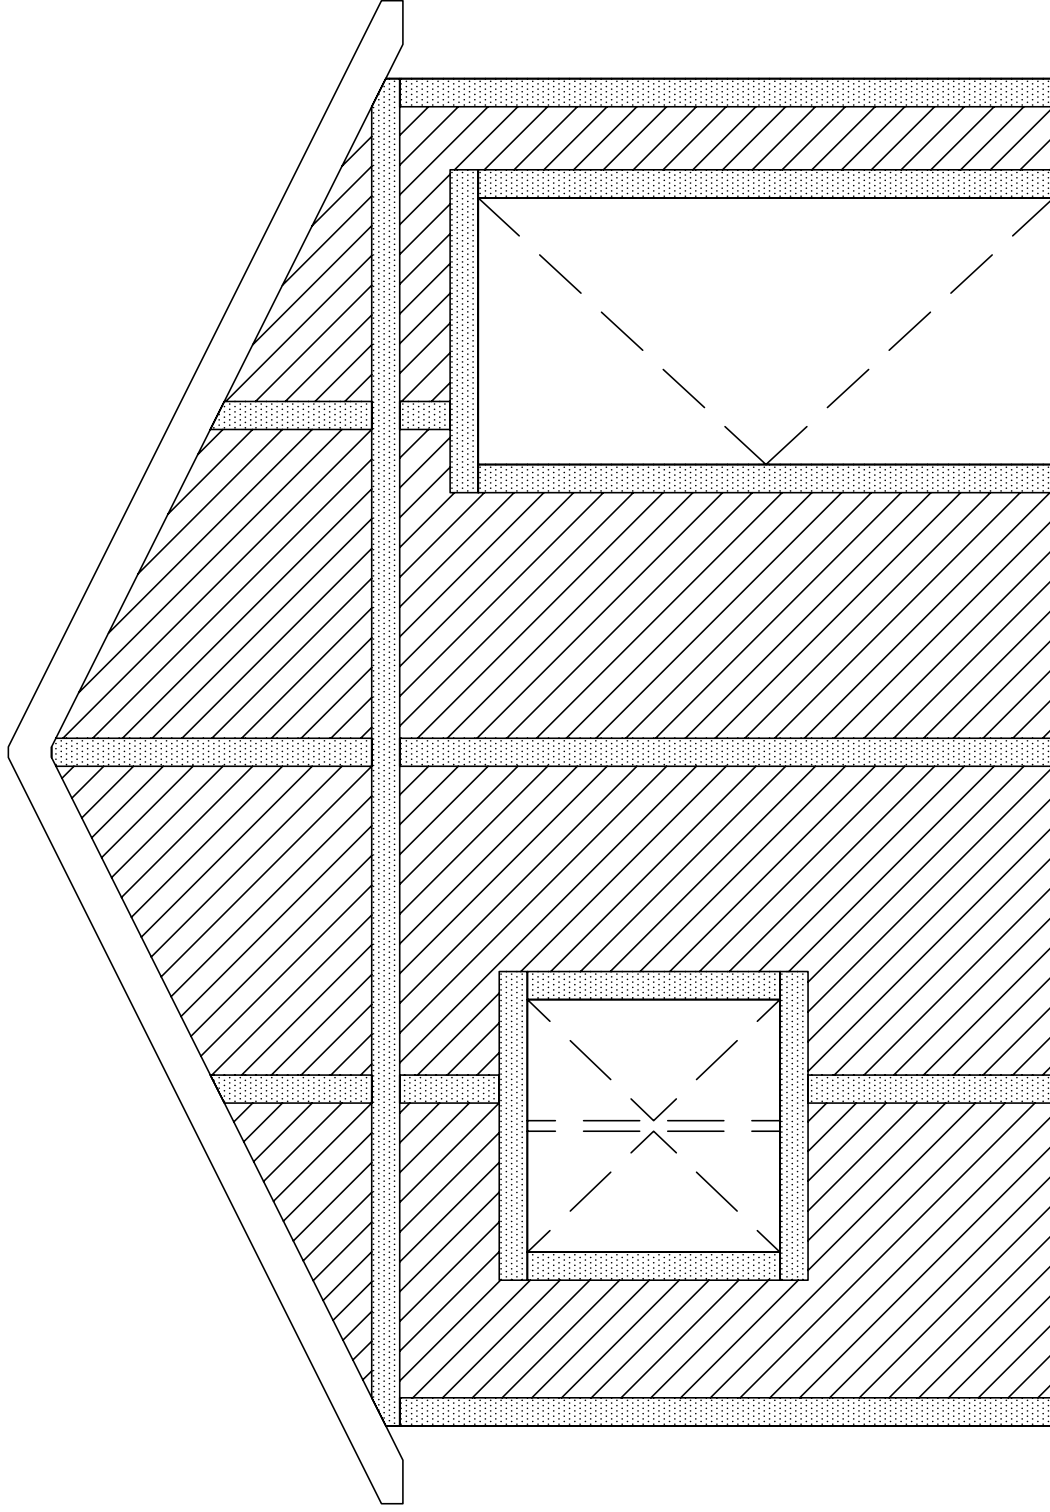

DETAIL 15 - TYPICAL TRIM


DAPIA SEAL	MODIFICATIONS	MODEL: House Plans for Zorrillo Club Quest	SHEET: D-15
		TITLE: Detail 15 Typical Trim	
<p>Unless the LORD builds the house, its builders labor in vain. Unless the LORD watches over the city, the watchmen stand guard in vain. Psalm 127:1</p>		DRAWN BY: MLEWISS	DATE: 5-20-06
		SCALE: NTS	

3/4" Plywood floor

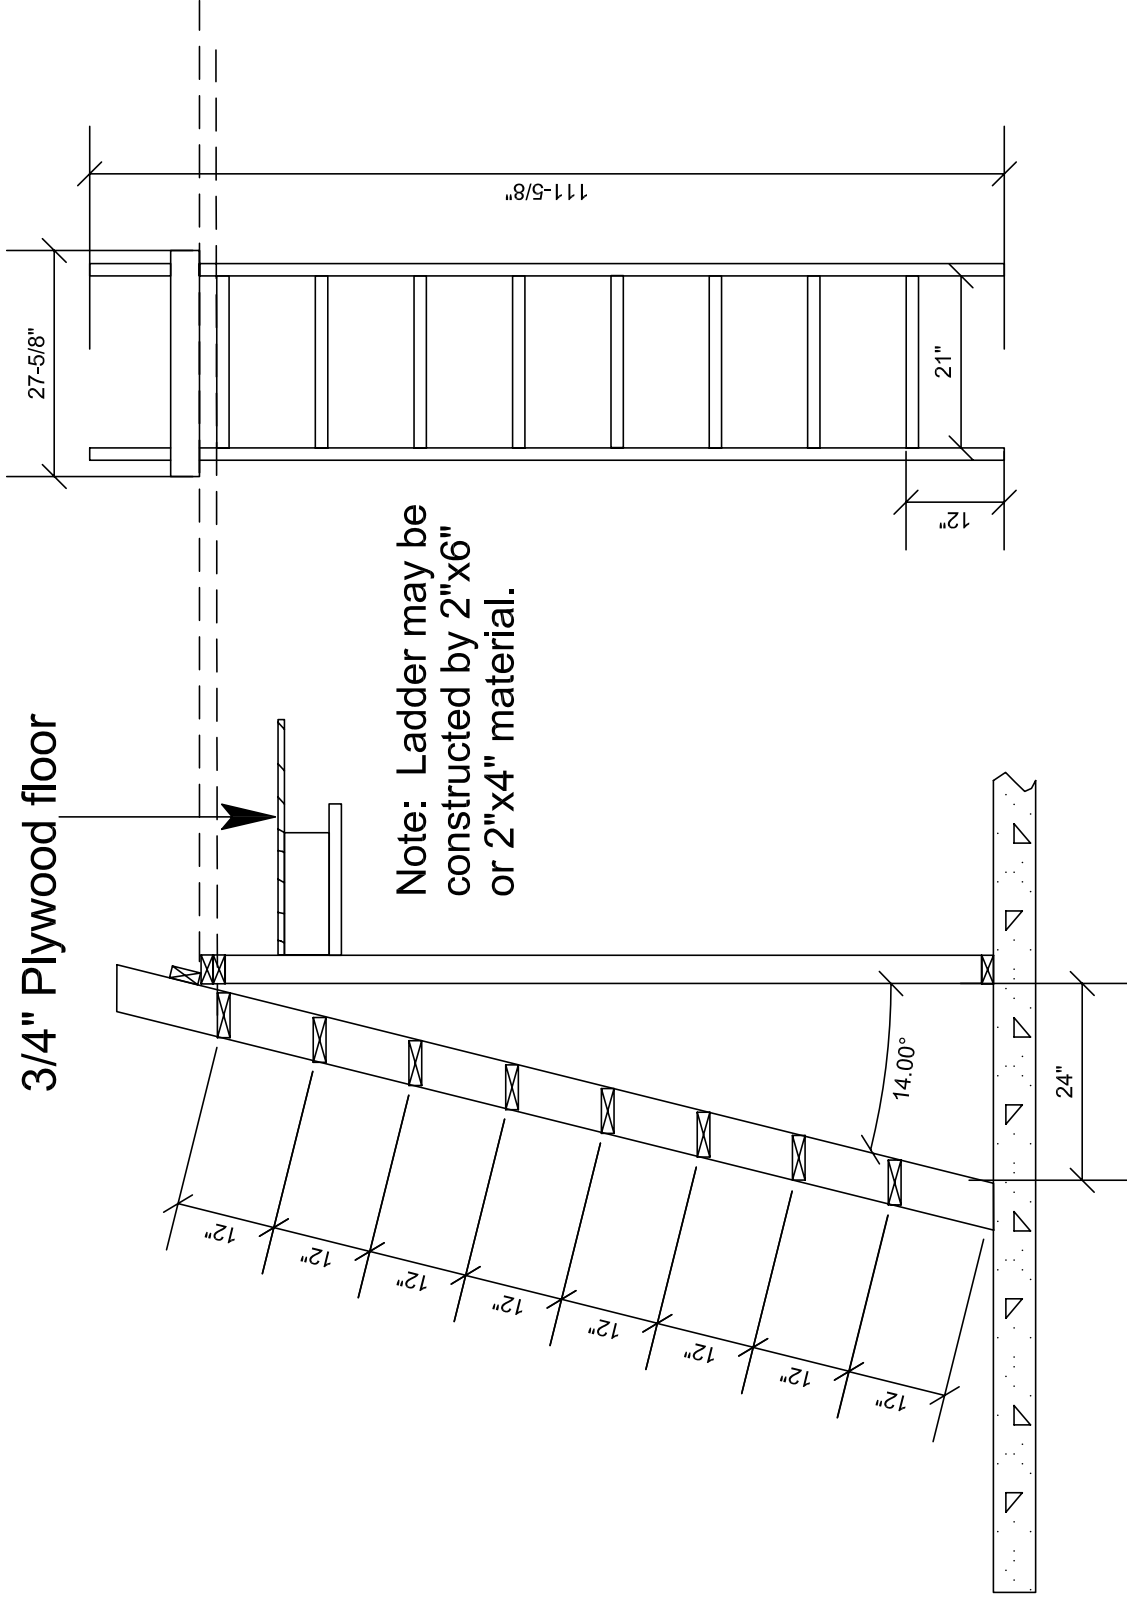



DETAIL 16 - LADDER

DAPIA SEAL	MODIFICATIONS	MODEL: House Plans for Zorrillo Club Quest	SHEET: D-16
		TITLE: Detail 16 Ladder	
<p>Unless the LORD builds the house, its builders labor in vain. Unless the LORD watches over the city, the watchmen stand guard in vain. Psalm 127:1</p>		DRAWN BY: MLEWISS	DATE: 5-20-06
		SCALE: 1/2" = 1'-0"	

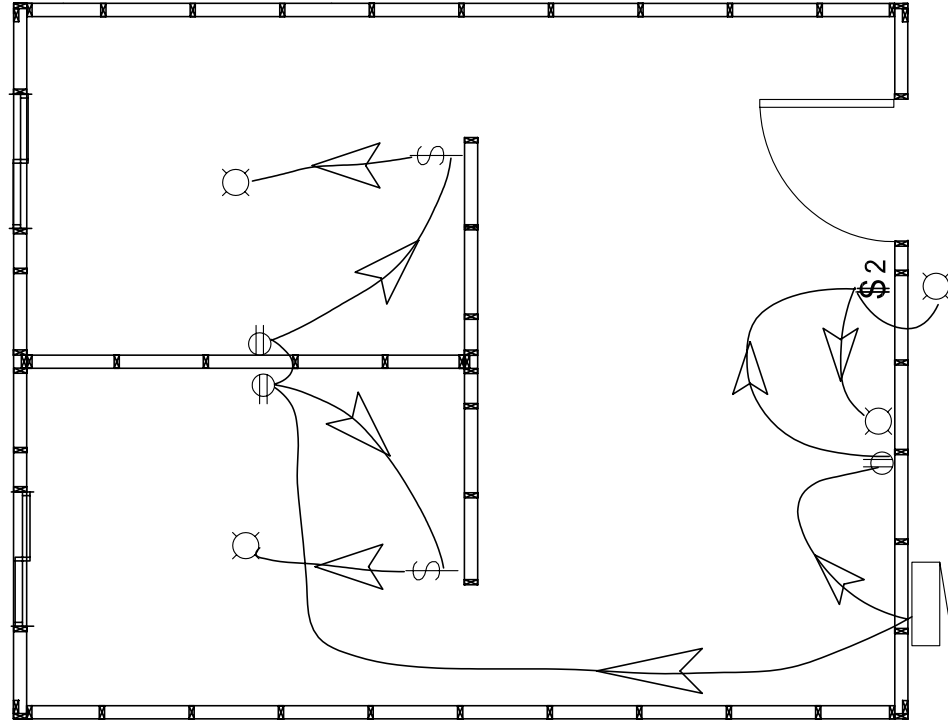


○ Lamp ⊕ Outlet \$ Switch \$2 Dbl Switch

2 Circuits:
 First one runs to the bedroom outlets then to the switches the to the lamps.
 Second one runs to the living room outlet - then to the switch then to the lamps.

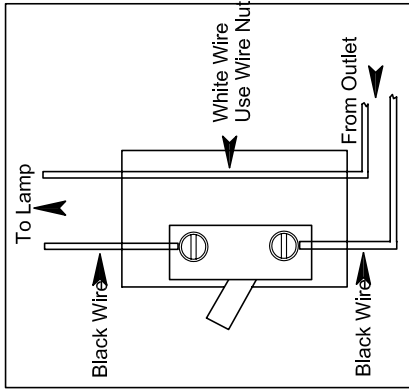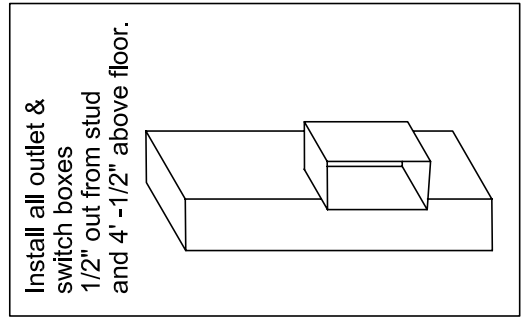


Electrical Outline


DAPIA SEAL	MODIFICATIONS	MODEL: House Plans for Zorrillo Club Quest	SHEET: E-1
		TITLE: Electrical Layout	
Unless the LORD builds the house, its builders labor in vain. Unless the LORD watches over the city, the watchmen stand guard in vain. Psalm 127:1		DRAWN BY: MLEWISS	DATE: 5-20-06
		SCALE: NTS	

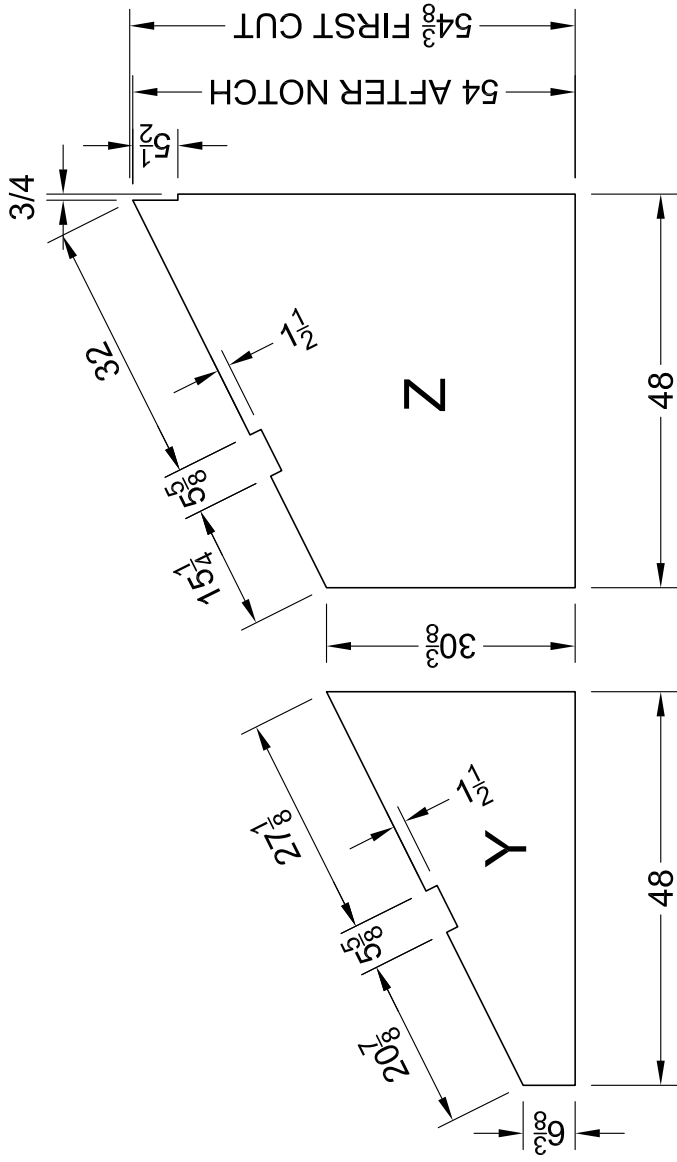







RIDGE LAYOUT

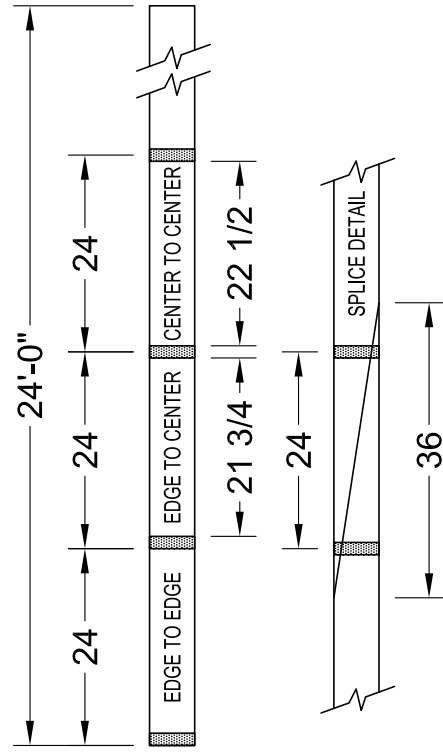

CEILING LAYOUT

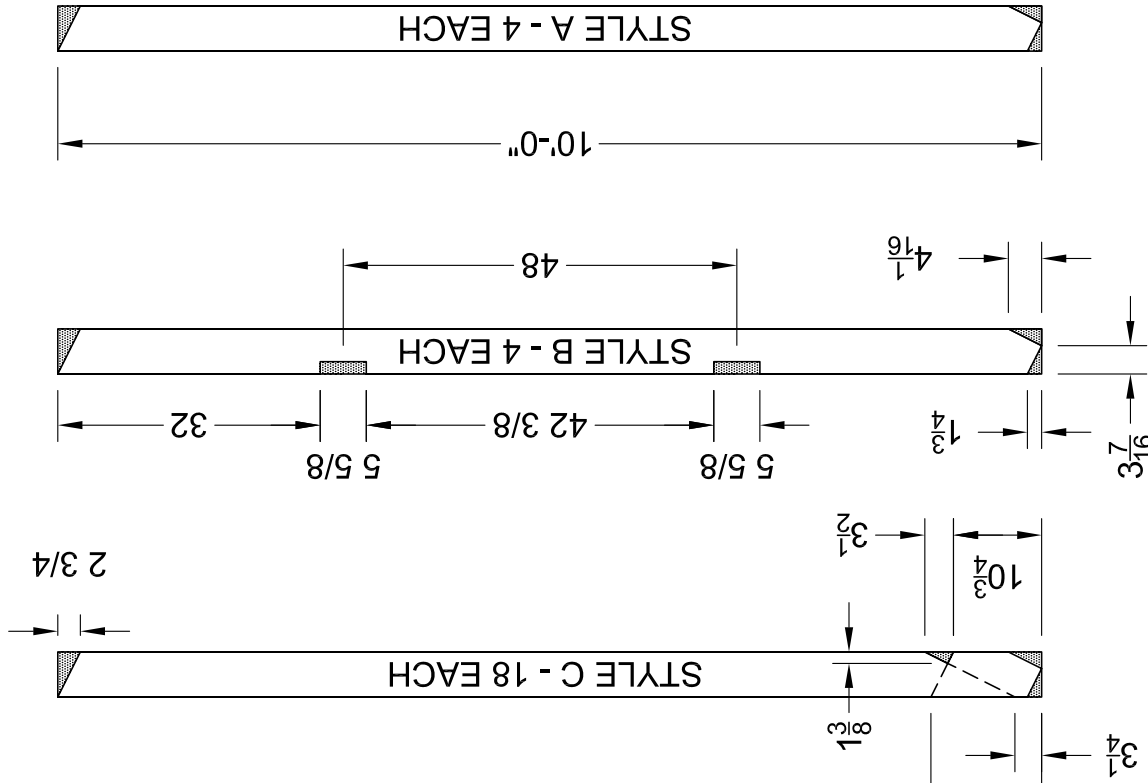

MODEL: House Plans for Zorrillo Club Quest		SHEET: CL-1	
TITLE: Ceiling Layout		DRAWN BY: M Lewis	
DATE: 5-20-06		SCALE: 1/2" = 1'-0"	
MODIFICATIONS		<p>Unless the LORD builds the house, its builders labor in vain. Unless the LORD watches over the city, the watchmen stand guard in vain. Psalm 127:1</p>	
DAPIA SEAL			

  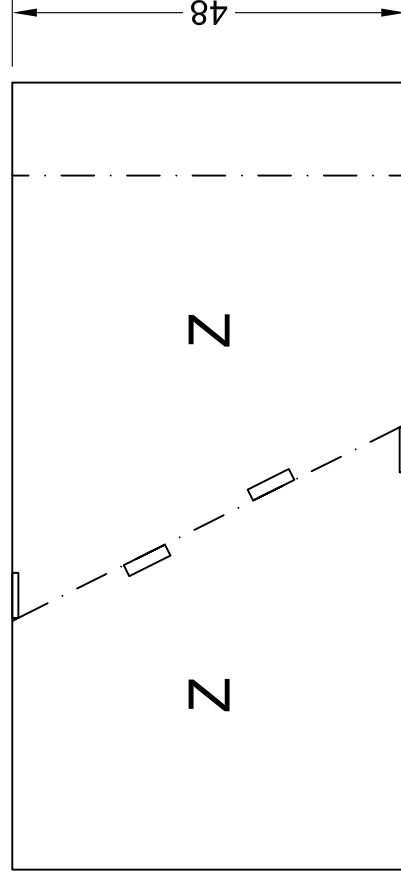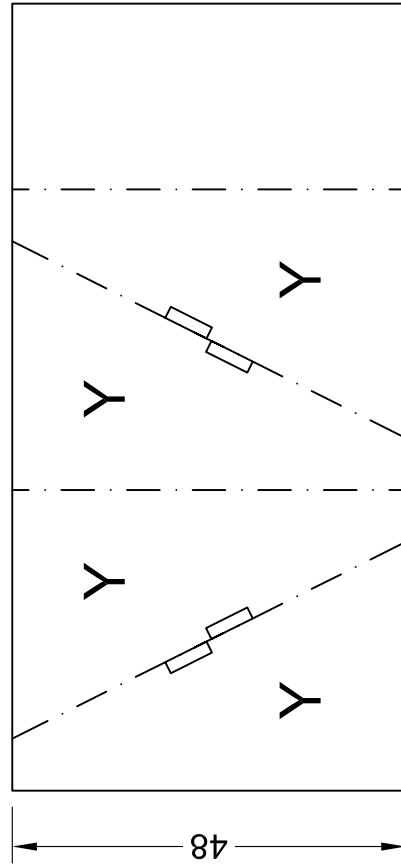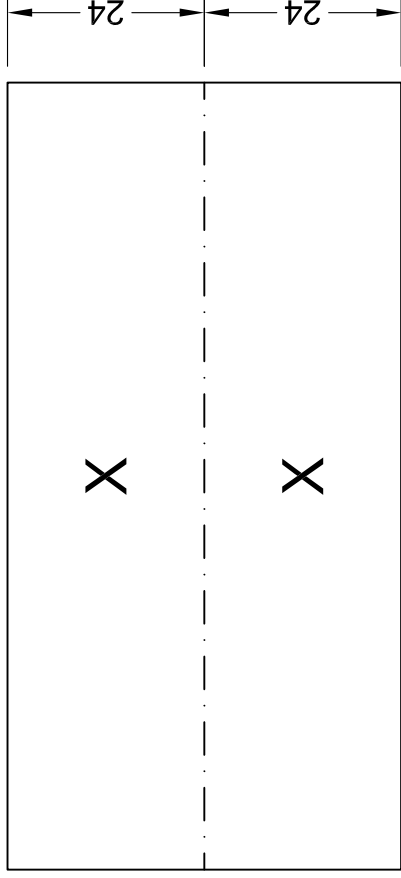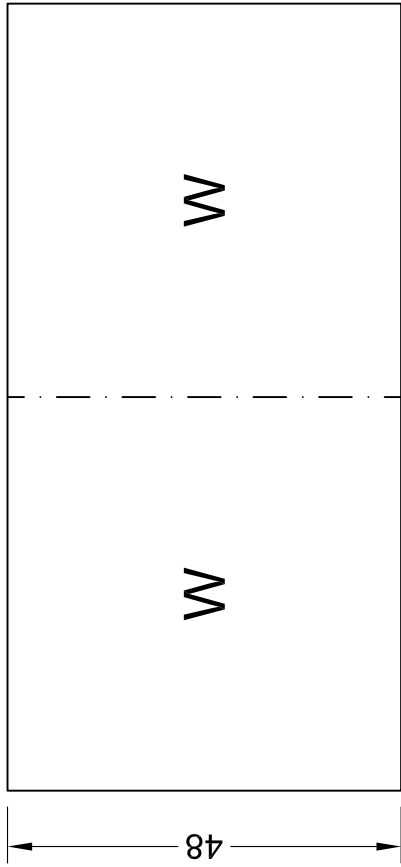

SEE CL-1 FOR DETAILS ON CUTTING NOTCHES FOR BARGE RAFTERS ON PIECES Y AND Z

PLYWOOD CUTTING DIAGRAM

DAPIA SEAL	MODIFICATIONS	MODEL: House Plans for Zorrillo Club Quest	SHEET: CL-2
		TITLE: Plywood Cutting Diagram	
Unless the LORD builds the house, its builders labor in vain. Unless the LORD watches over the city, the watchmen stand guard in vain. Psalm 127:1		DRAWN BY: MLEWISS	DATE: 5-20-06
		SCALE: 1/4" = 1'-0"	